



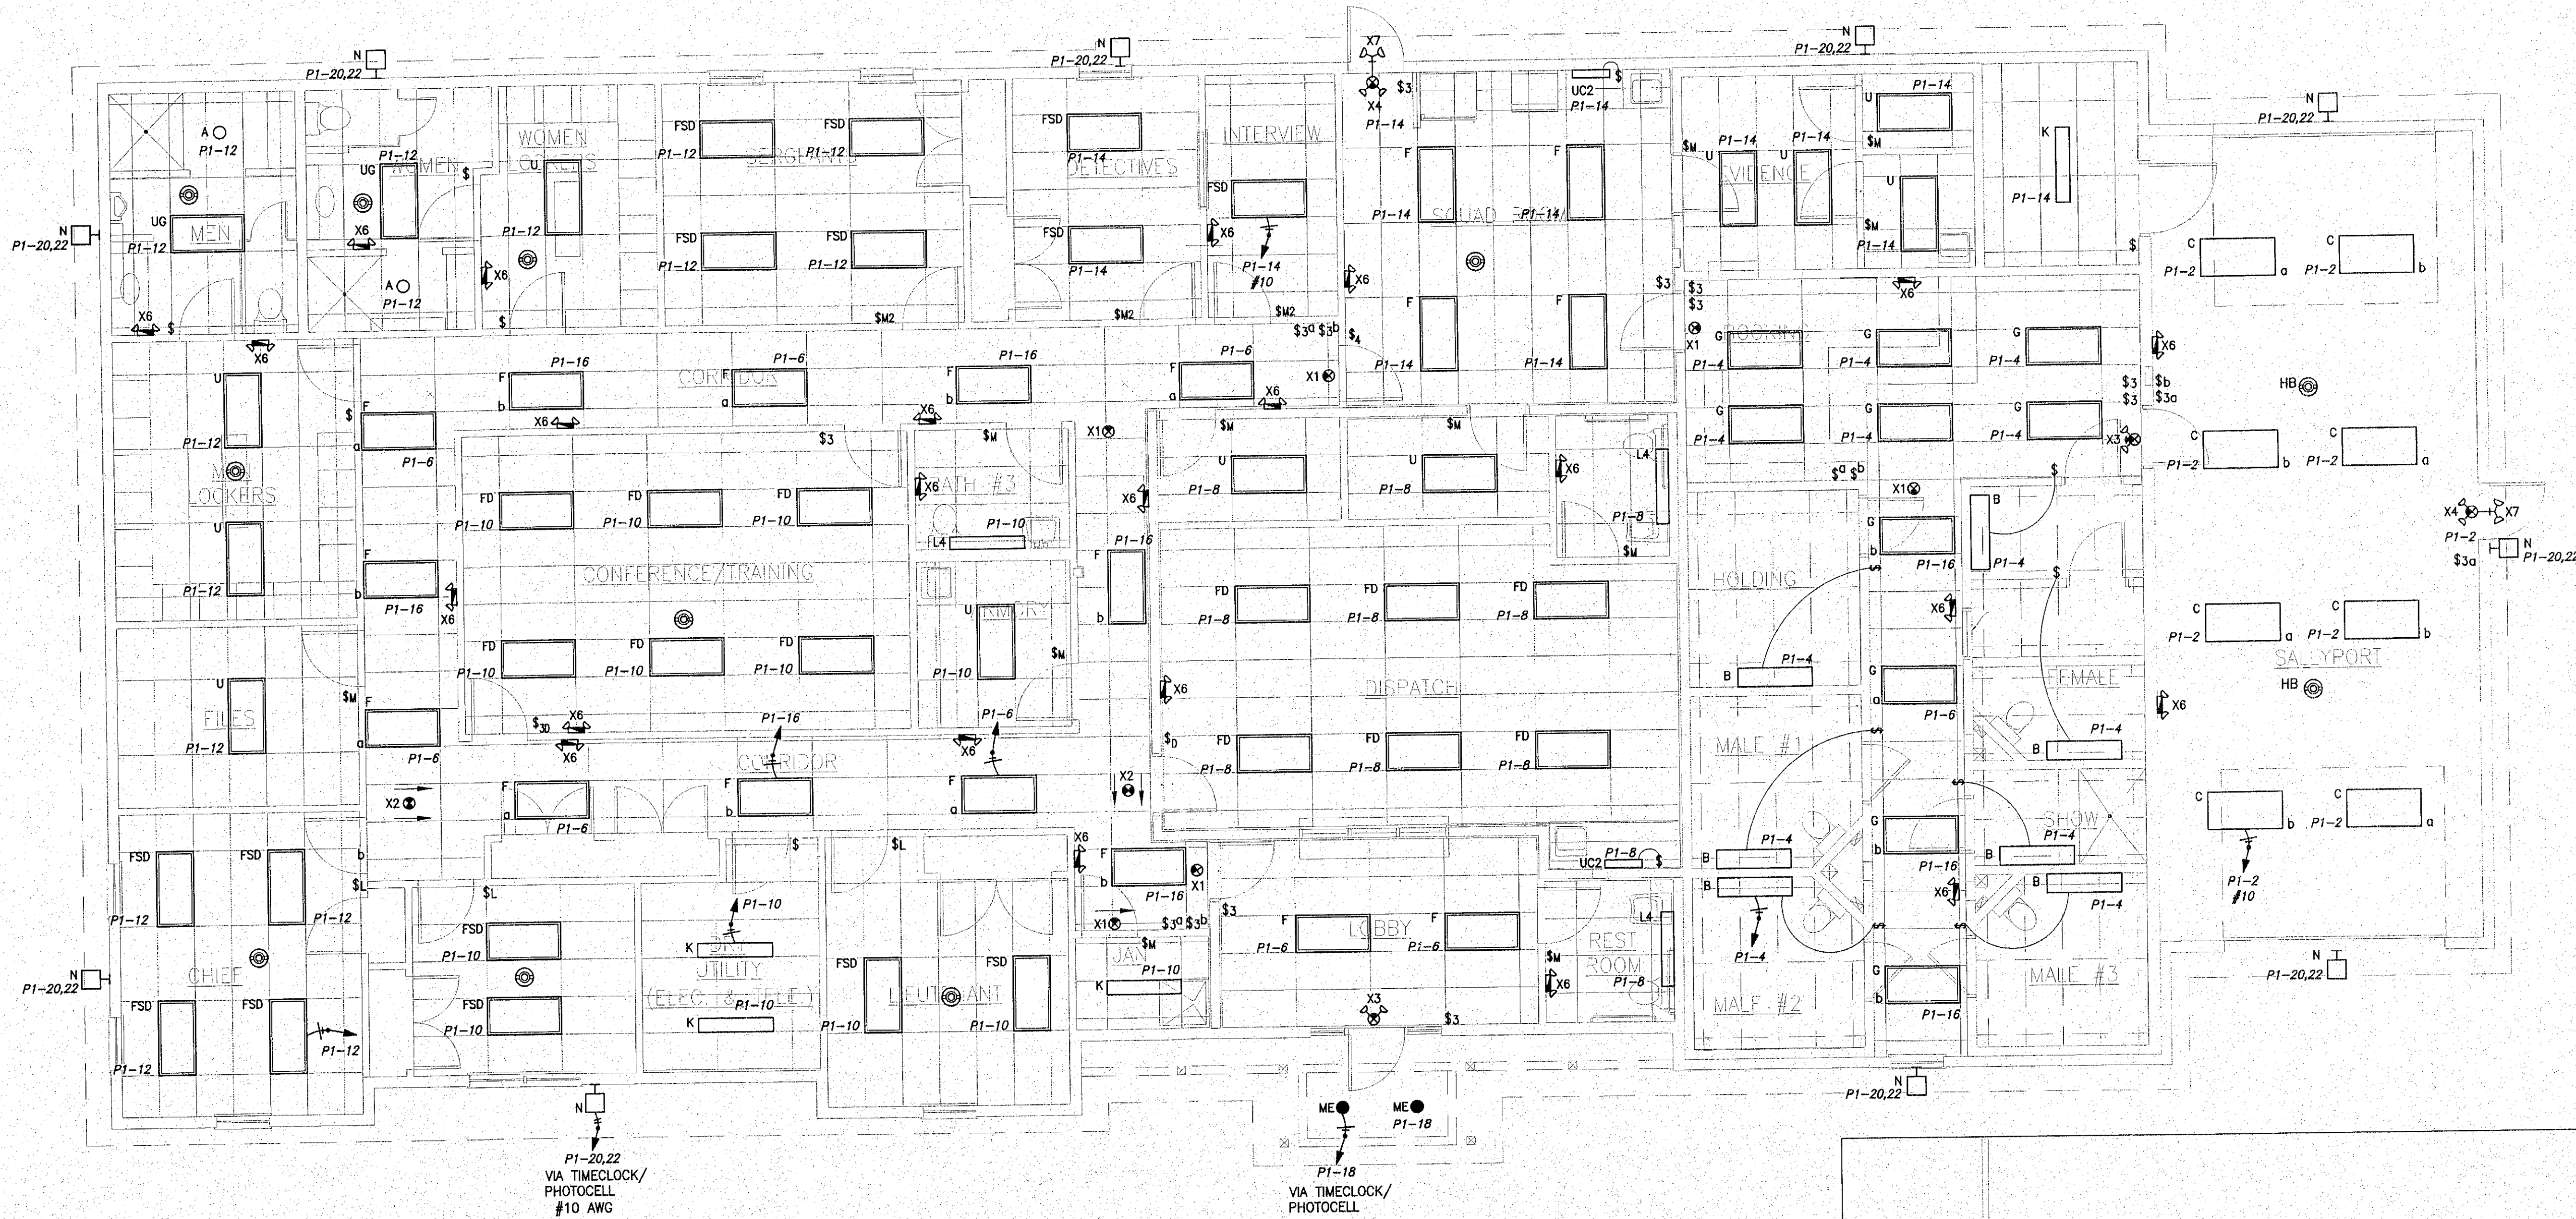

1
E-3

LIGHTING - FLOOR PLAN

SCALE: 3/16"=1'-0"

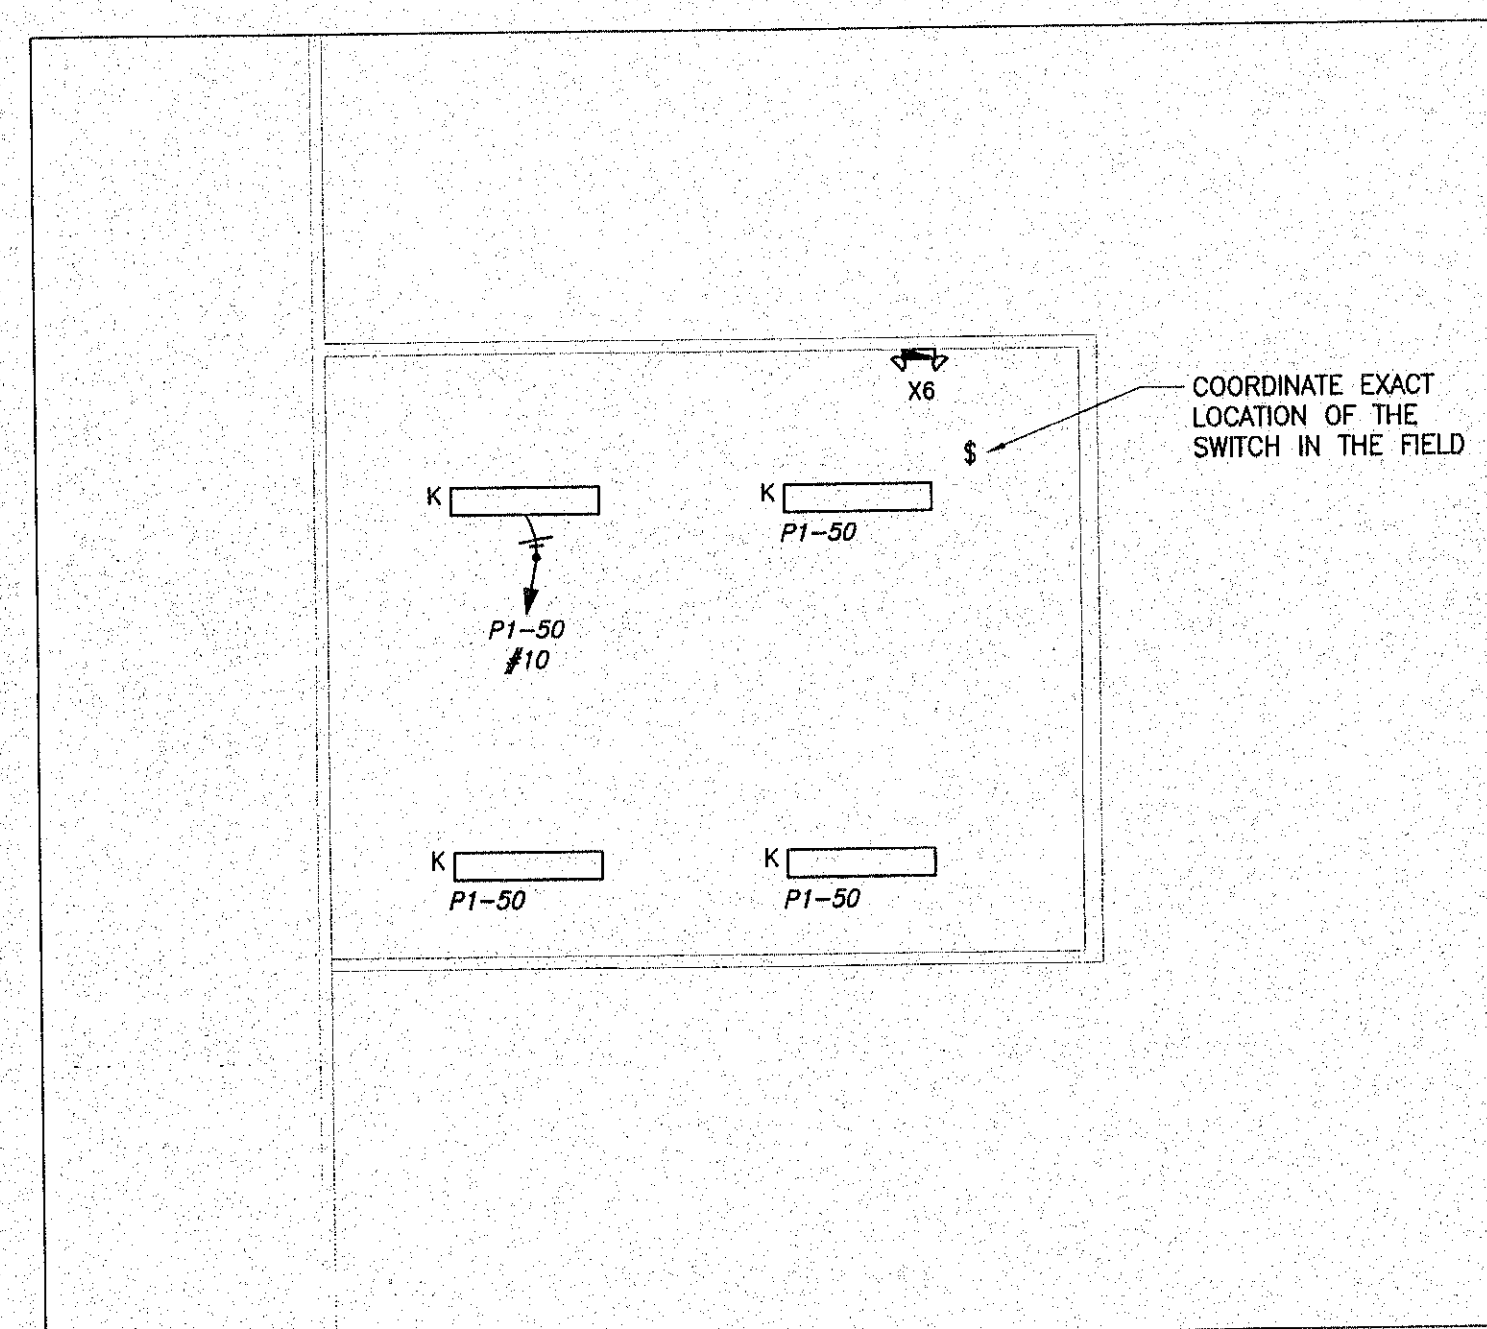

2
E-3

LIGHTING - ATTIC PLAN

SCALE: 3/16"=1'-0"

MENDON
POLICE
STATION

LIGHTING
FLOOR PLAN


DATE: 12/21/12
SCALE: 3/16"=1'-0"
DRAWN BY: NAJ
CHECKED BY: AR

Sheet 10 OF 25


E3

R.C. Searles Associates
Exclusive Home Designers
Design / Build
Phone No. 17 Glenwood St.
(508) 466-3202 Holden Ma.

CONSULTING ARCHITECT
J THOMAS REARDON
7 SUNSET DRIVE
NORTHBOROUGH MA
01532

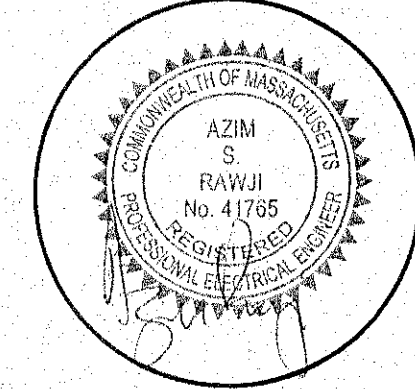

NOTICE OF COPYRIGHT
Pursuant to the Federal Copyright Act, these plans whether a preliminary layout or sketch, full construction set, bidding set, study set or extra prints, contain the copyright notice and are duly registered with Library of Congress - property of R.C. Searles Associates. These plans may be used only once, unless a signed written agreement between this office and client is approved. Any re-drawing, tracing, reproduction, re-use or formation of derivative works is prohibited and any violators will be prosecuted to the fullest extent of the law.

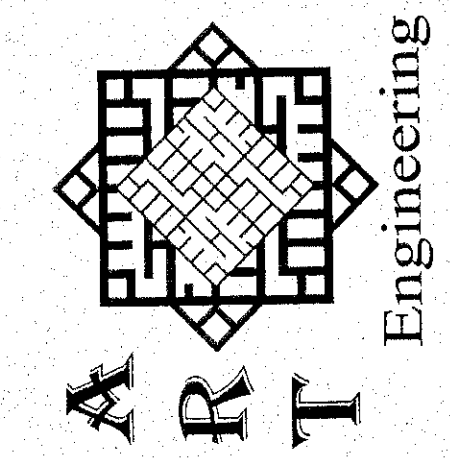

76 Webster Street
Worcester, MA 01603
508-797-0333 Phone
508-458-4111 Fax
www.engineering.us

WWW.RCSEARLES.COM