



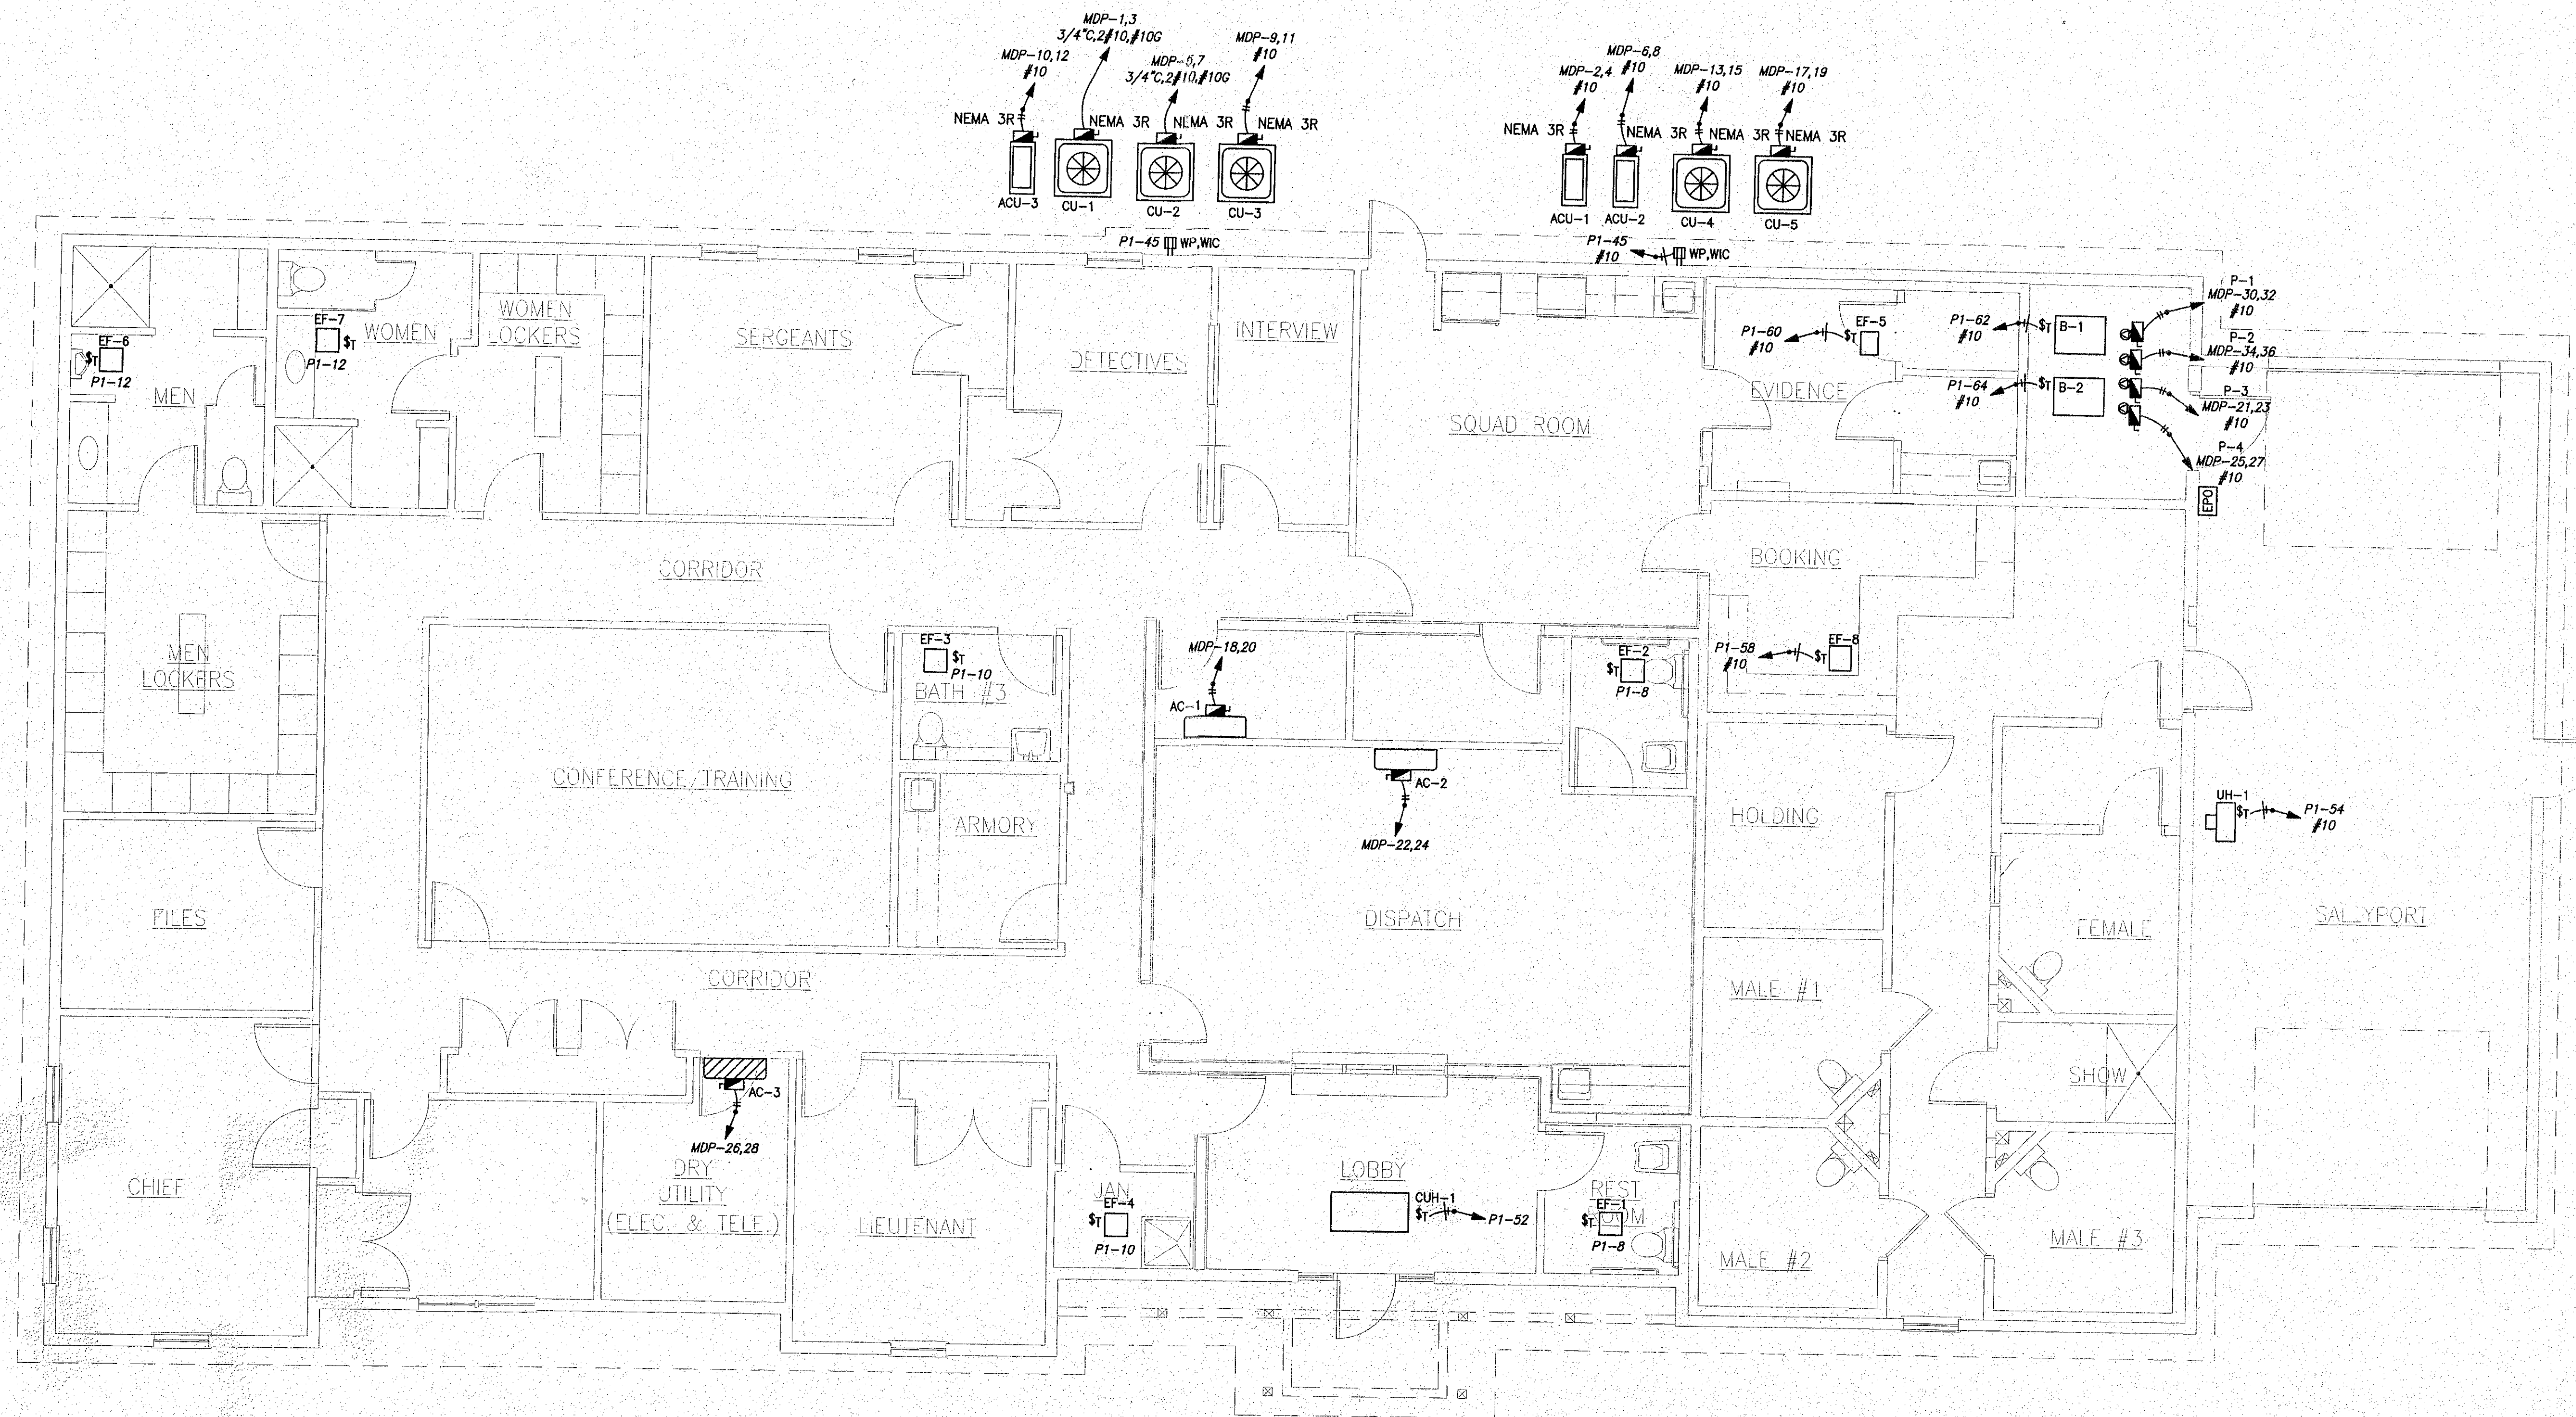

1
E-4

HVAC POWER - FLOOR PLAN

SCALE: 3/16"=1'-0"

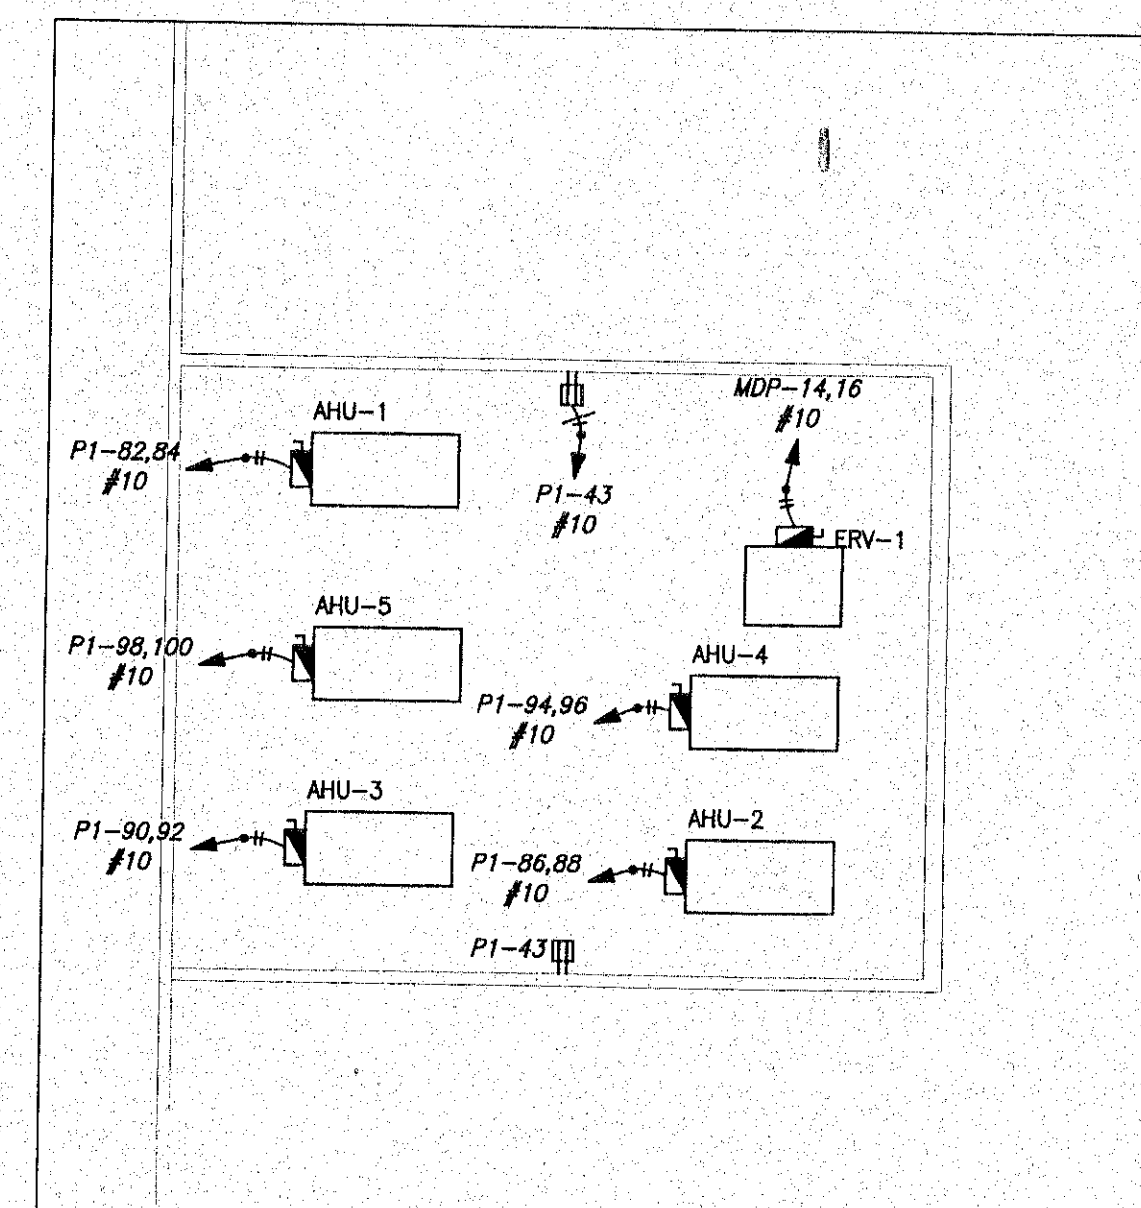


2
E-4

HVAC POWER - ATTIC PLAN

SCALE: 3/16"=1'-0"


76 Webster Street
Worcester, MA 01603
508-797-0333 Phone
508-458-4111 Fax
www.engineering.us

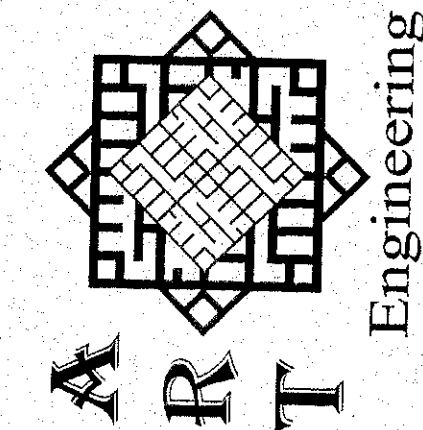

R.C. Searles Associates
Exclusive Home Designers
Design / Build
Phone No. (508) 466-3202
17 Glenwood St.
Holden Ma.

NOTICE OF COPYRIGHT
Pursuant to the Federal Copyright Act, these plans whether a preliminary layout or sketch, full construction set, partial set, bidding set, study set or extra prints, contain the copyright notice and are duly registered with Library of Congress. Properly reserving all rights for R.C. Searles Associates. These plans may be used only once, for the project and site for which they were prepared. No reproduction, re-use or formation of derivative work is expressly prohibited and any violators will be prosecuted to the fullest extent of the law.

CONSULTING ARCHITECT
J. THOMAS REARDON
7 SUNSET DRIVE
NORTHBOROUGH MA
01532

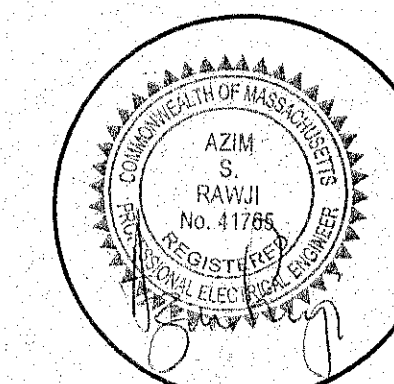

MENDON
POLICE
STATION

HVAC POWER
FLOOR PLAN

DATE: 12/21/12

SCALE: 3/16"=1'-0"

DRAWN BY: N/AJ

CHECKED BY: AR

Sheet 12 OF 25

E5

WWW.RCSEARLES.COM