


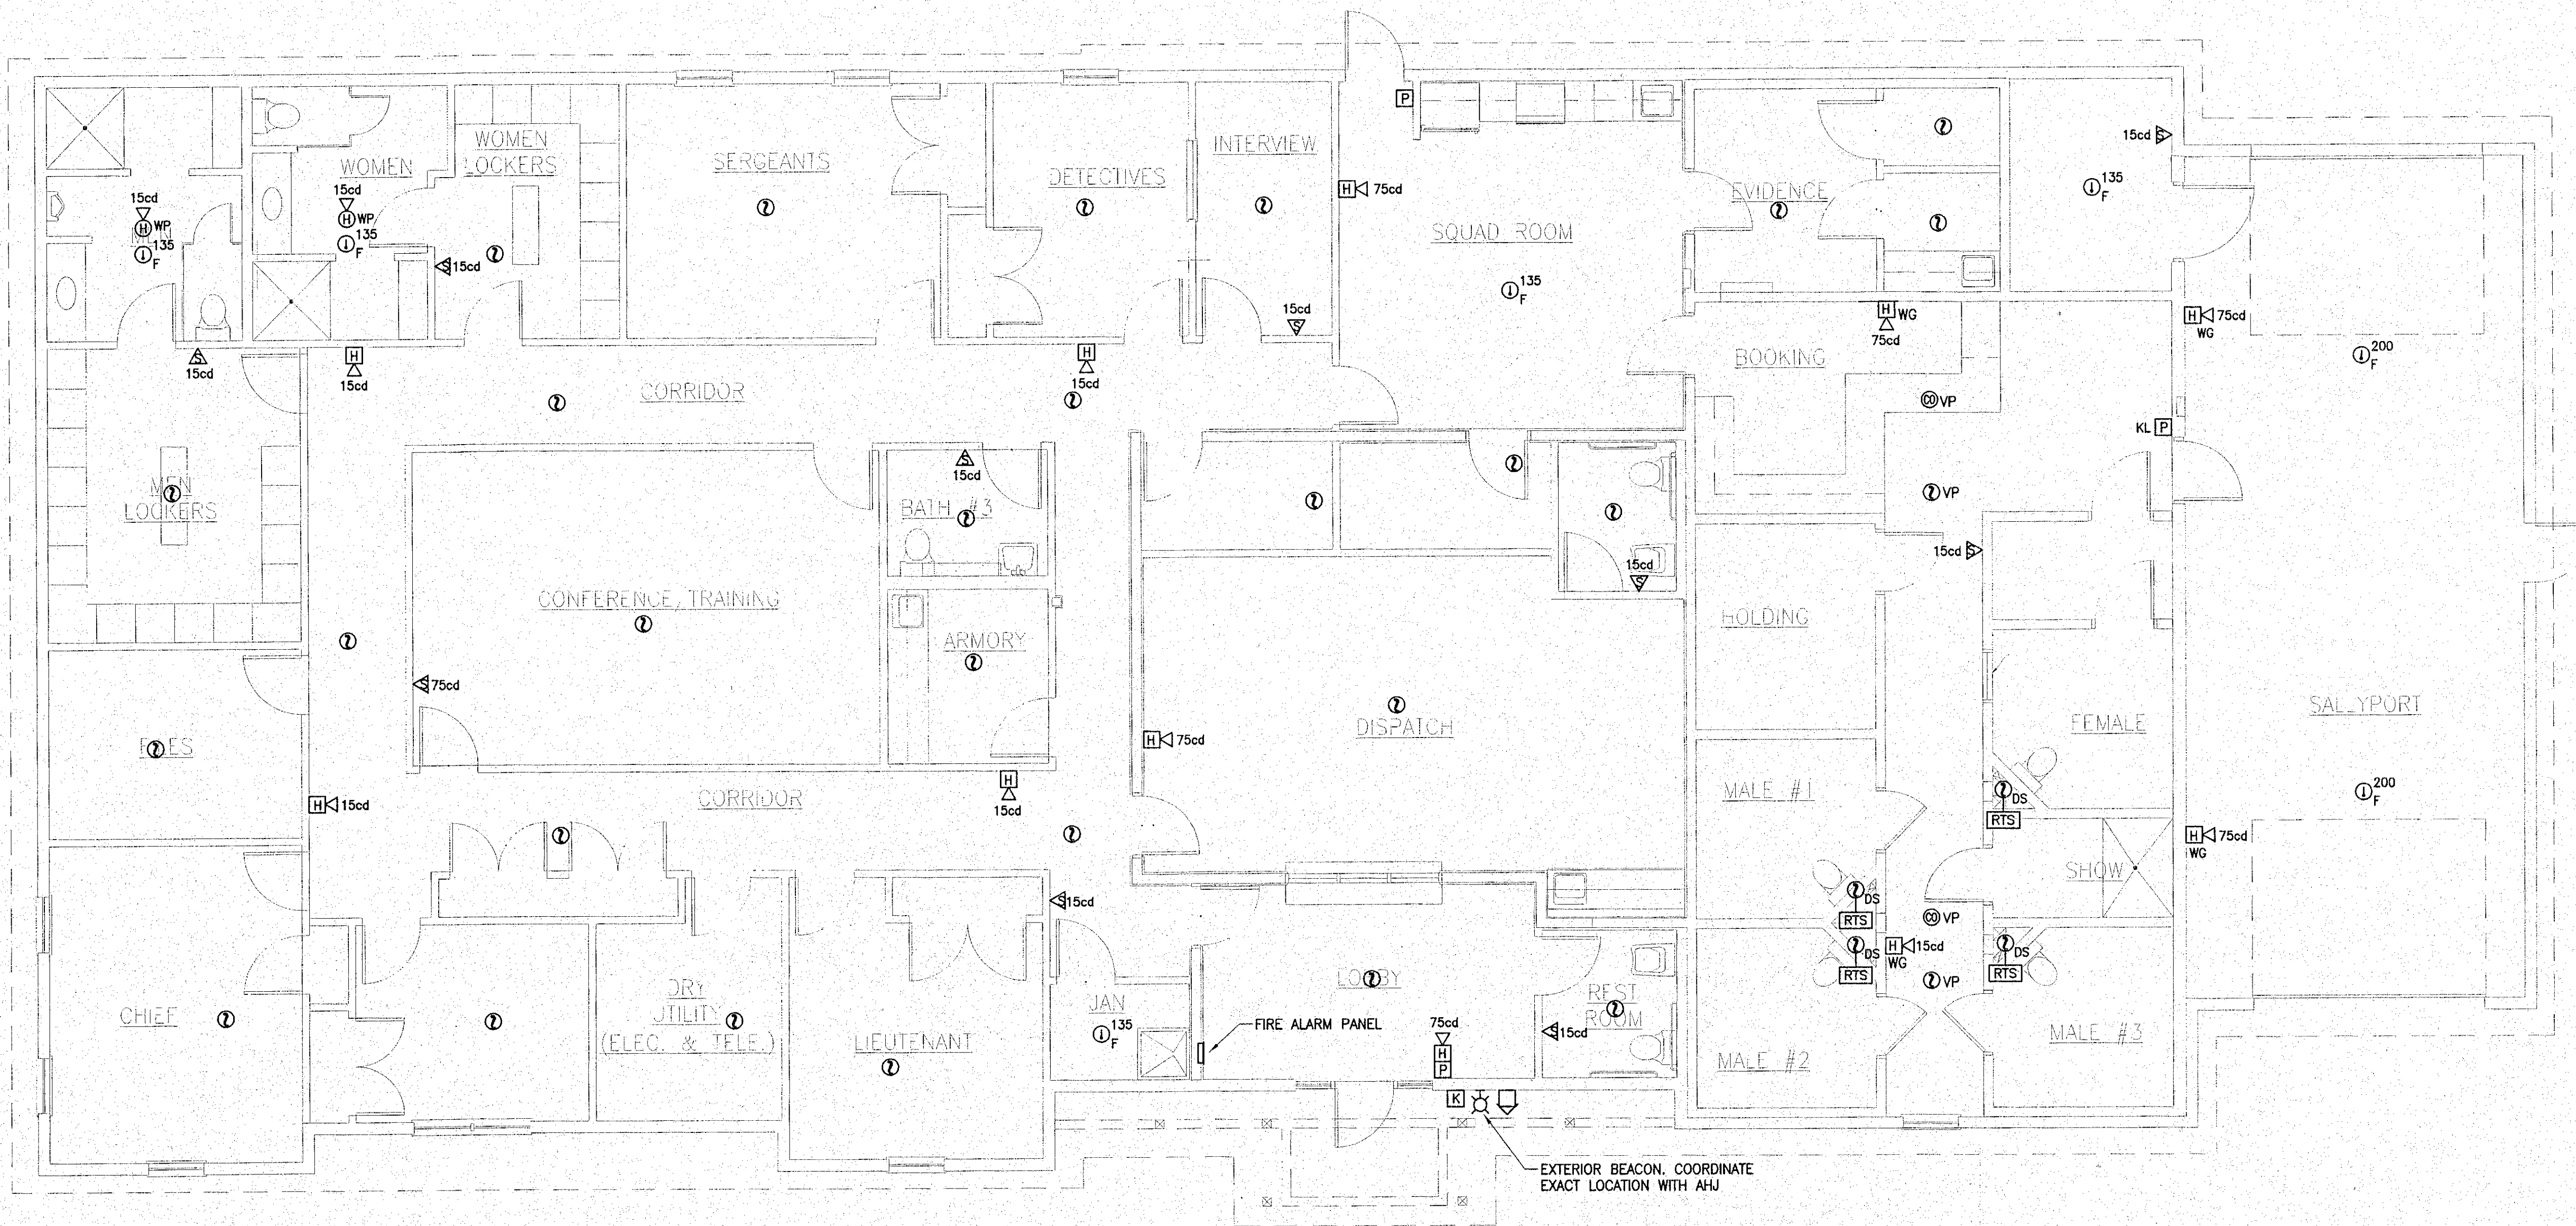

1
E-6

FIRE ALARM - FLOOR PLAN

SCALE: 3/16"=1'-0"

2

E-6

FIRE ALARM - ATTIC PLAN

SCALE: 3/16"=1'-0"

MENDON
POLICE
STATION

FIRE ALARM
FLOOR PLAN

DATE: 12/21/12

SCALE: 3/16"=1'-0"

DRAWN BY: NAJ


CHECKED BY: AR

Sheet 13 OF 25

E6

R.C. Searles Associates
Exclusive Home Designers
Design / Build


Phone No. 17 Glenwood St.
(508) 466-3202 Holden Ma.

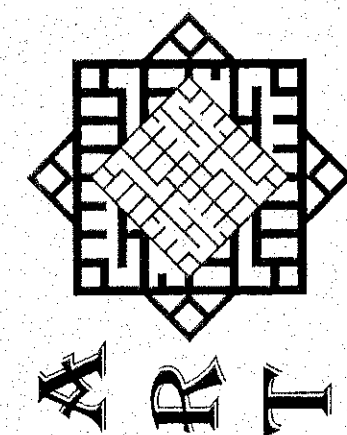

76 Webster Street
Worcester, MA 01603
508-797-0333 Phone
508-458-4111 Fax
www.engineering.us

NOTICE OF COPYRIGHT
Pursuant to the Federal Copyright Act, these plans whether a preliminary layout or
schematic, full construction set, bidding set, study set or extra prints, contain
the copyright notice and are the property of R.C. Searles Associates, Inc. No part
of this document may be reproduced, stored in a retrieval system, or transmitted
in any form or by any means, electronic, mechanical, photocopying, recording,
redrawing, tracing, reproduction, re-use or formation of derivative work is expressly
prohibited and any violators will be prosecuted to the fullest extent of the law.

CONSULTING ARCHITECT
J. THOMAS REARDON
7 SUNSET DRIVE
NORTHBOROUGH MA
01532

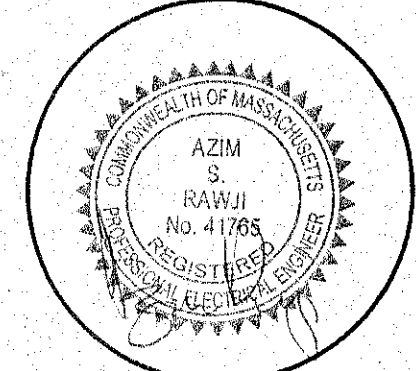

WWW.RCSEARLES.COM