

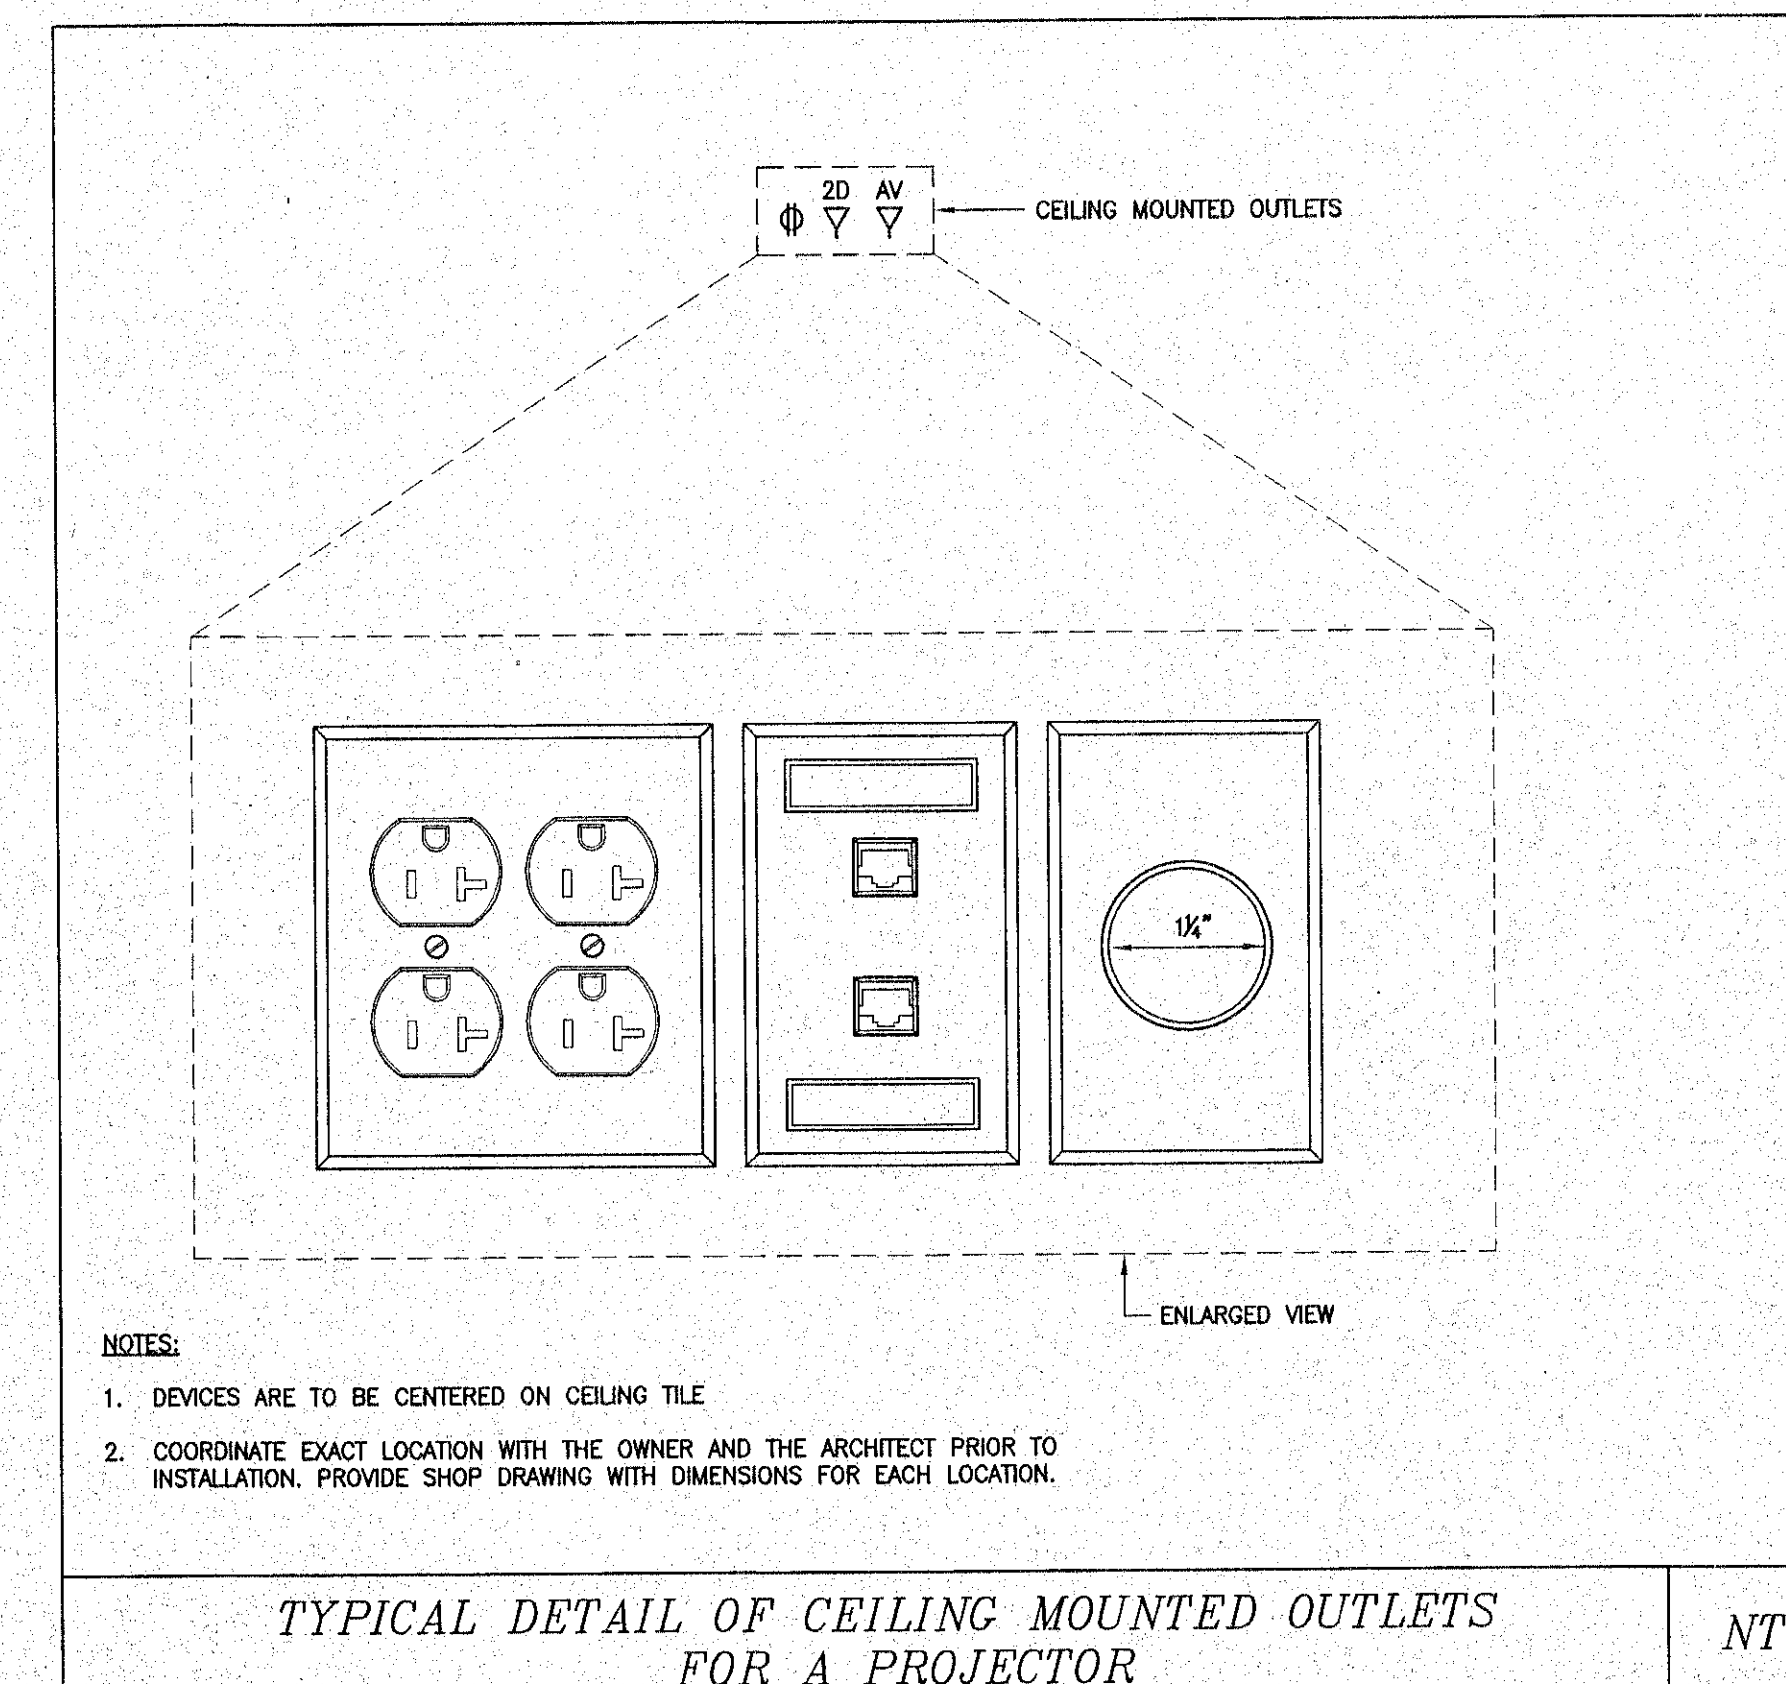
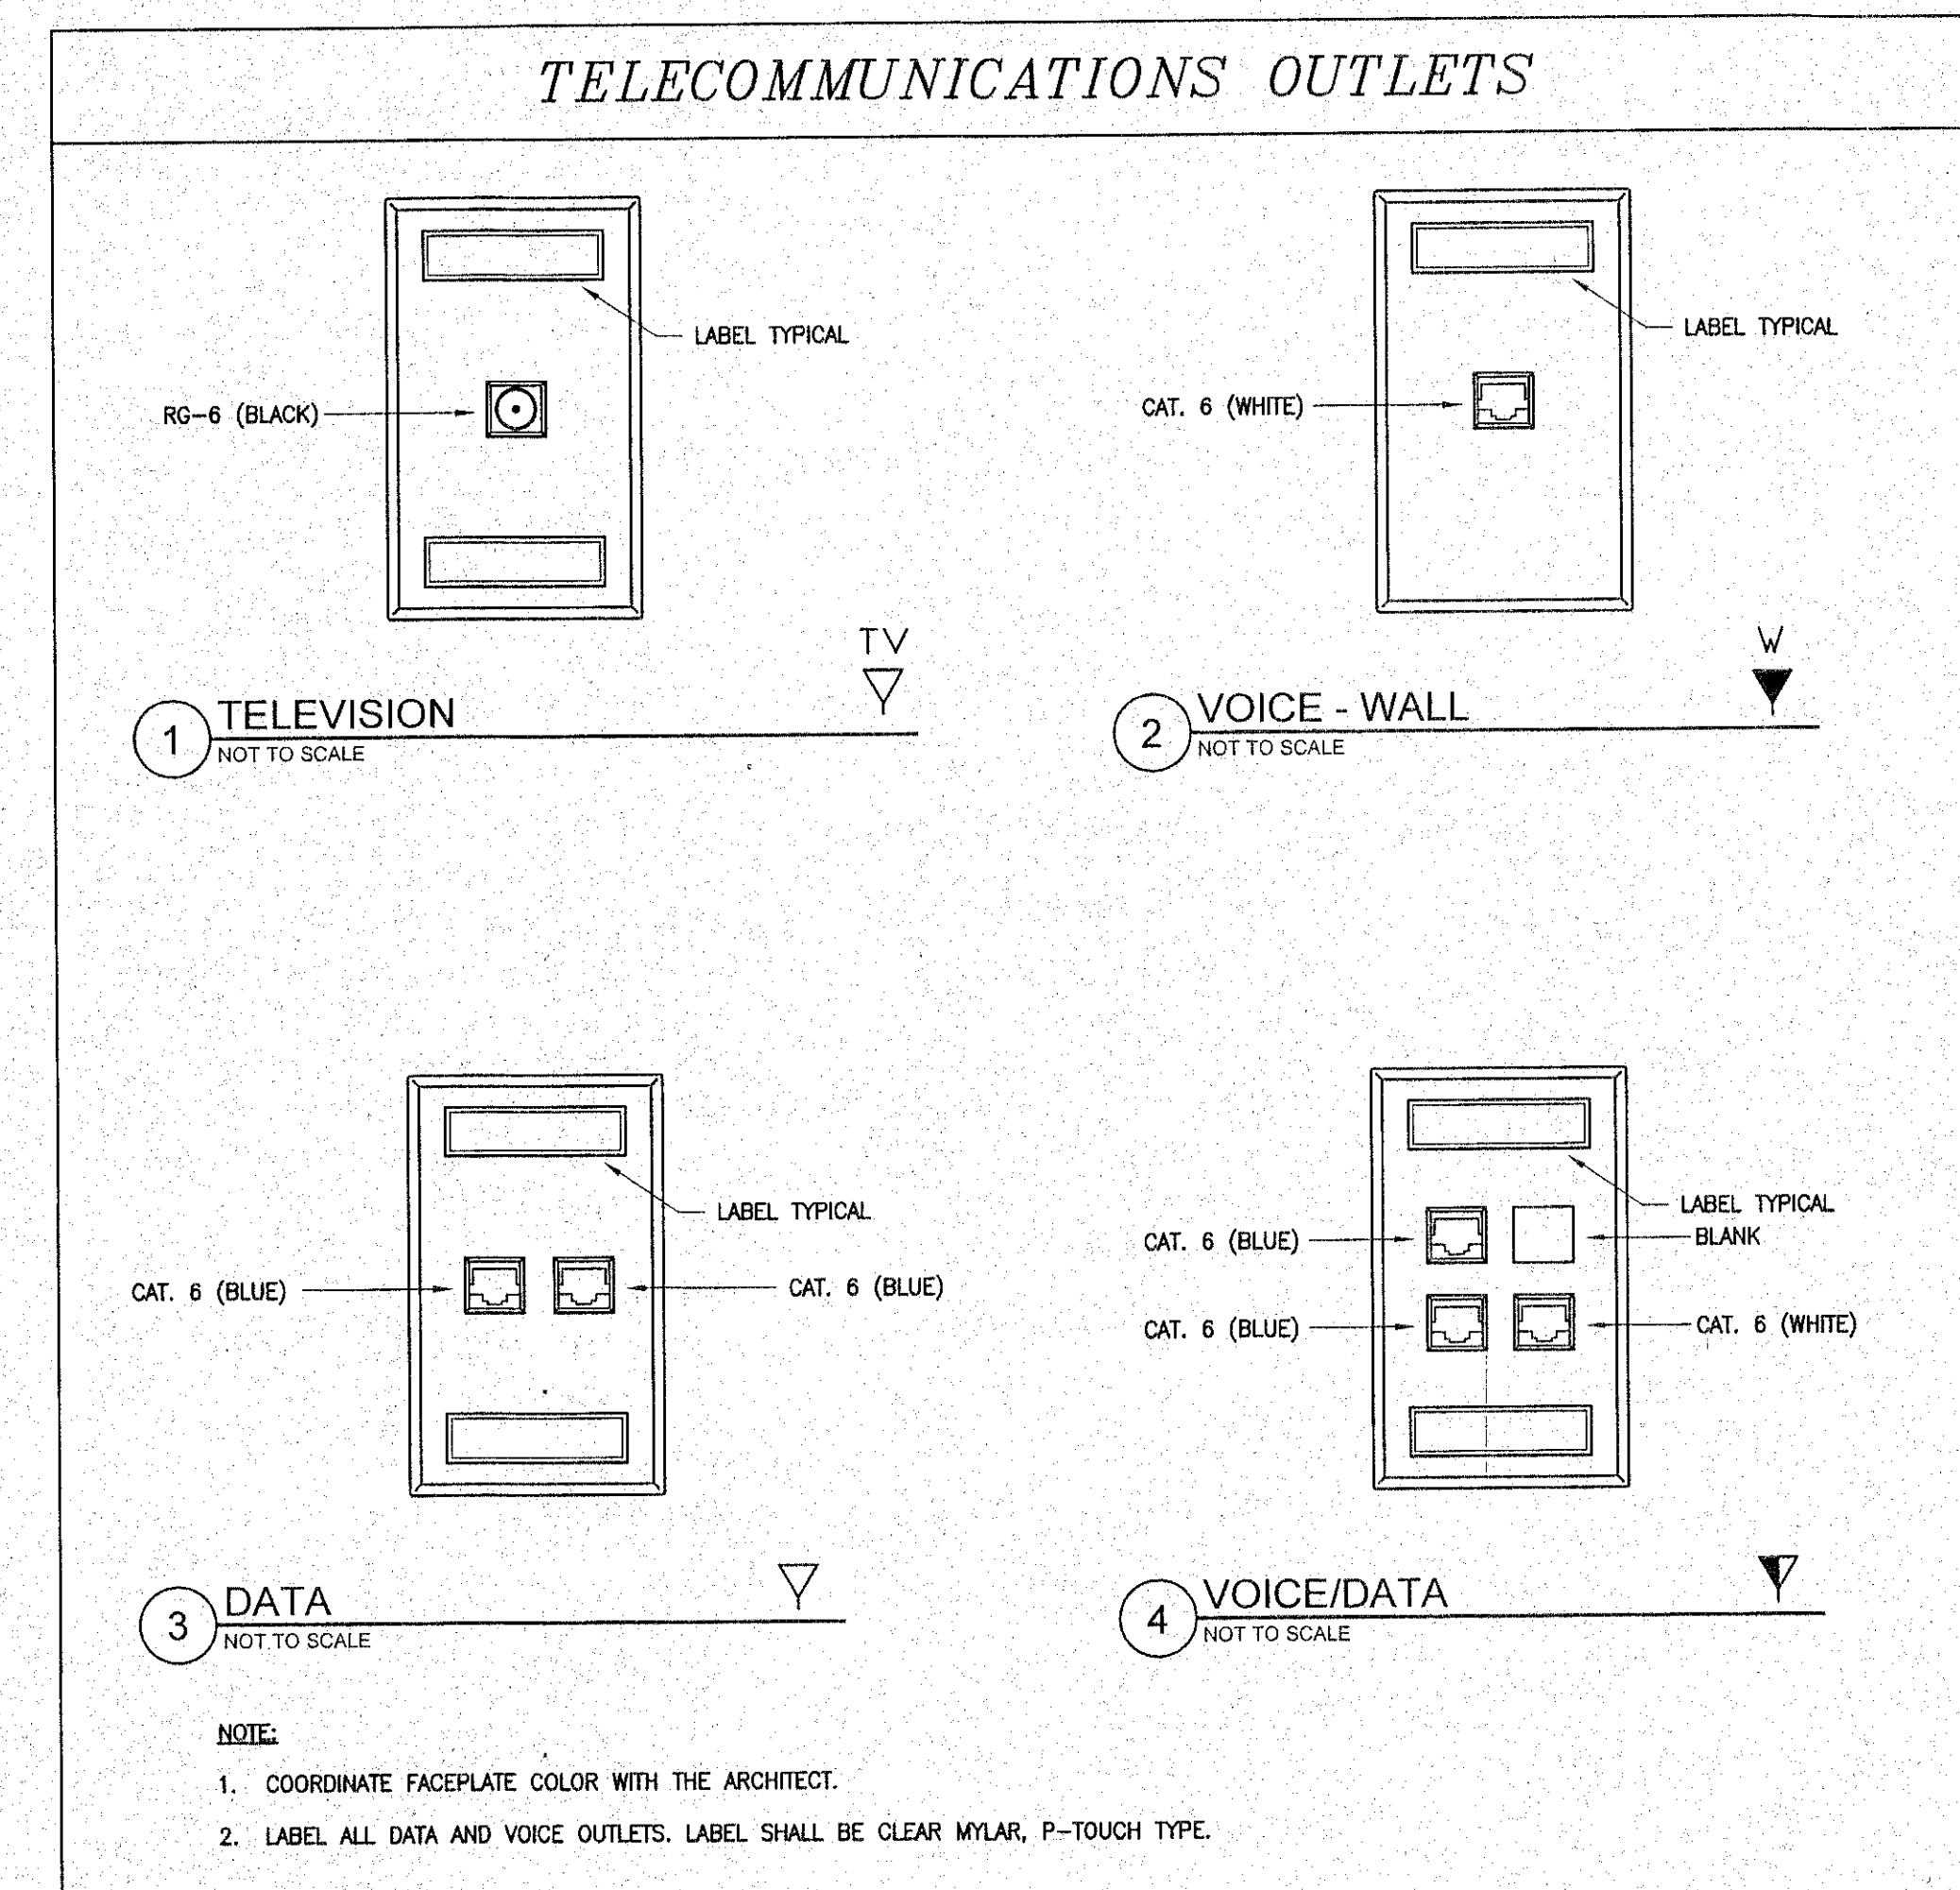
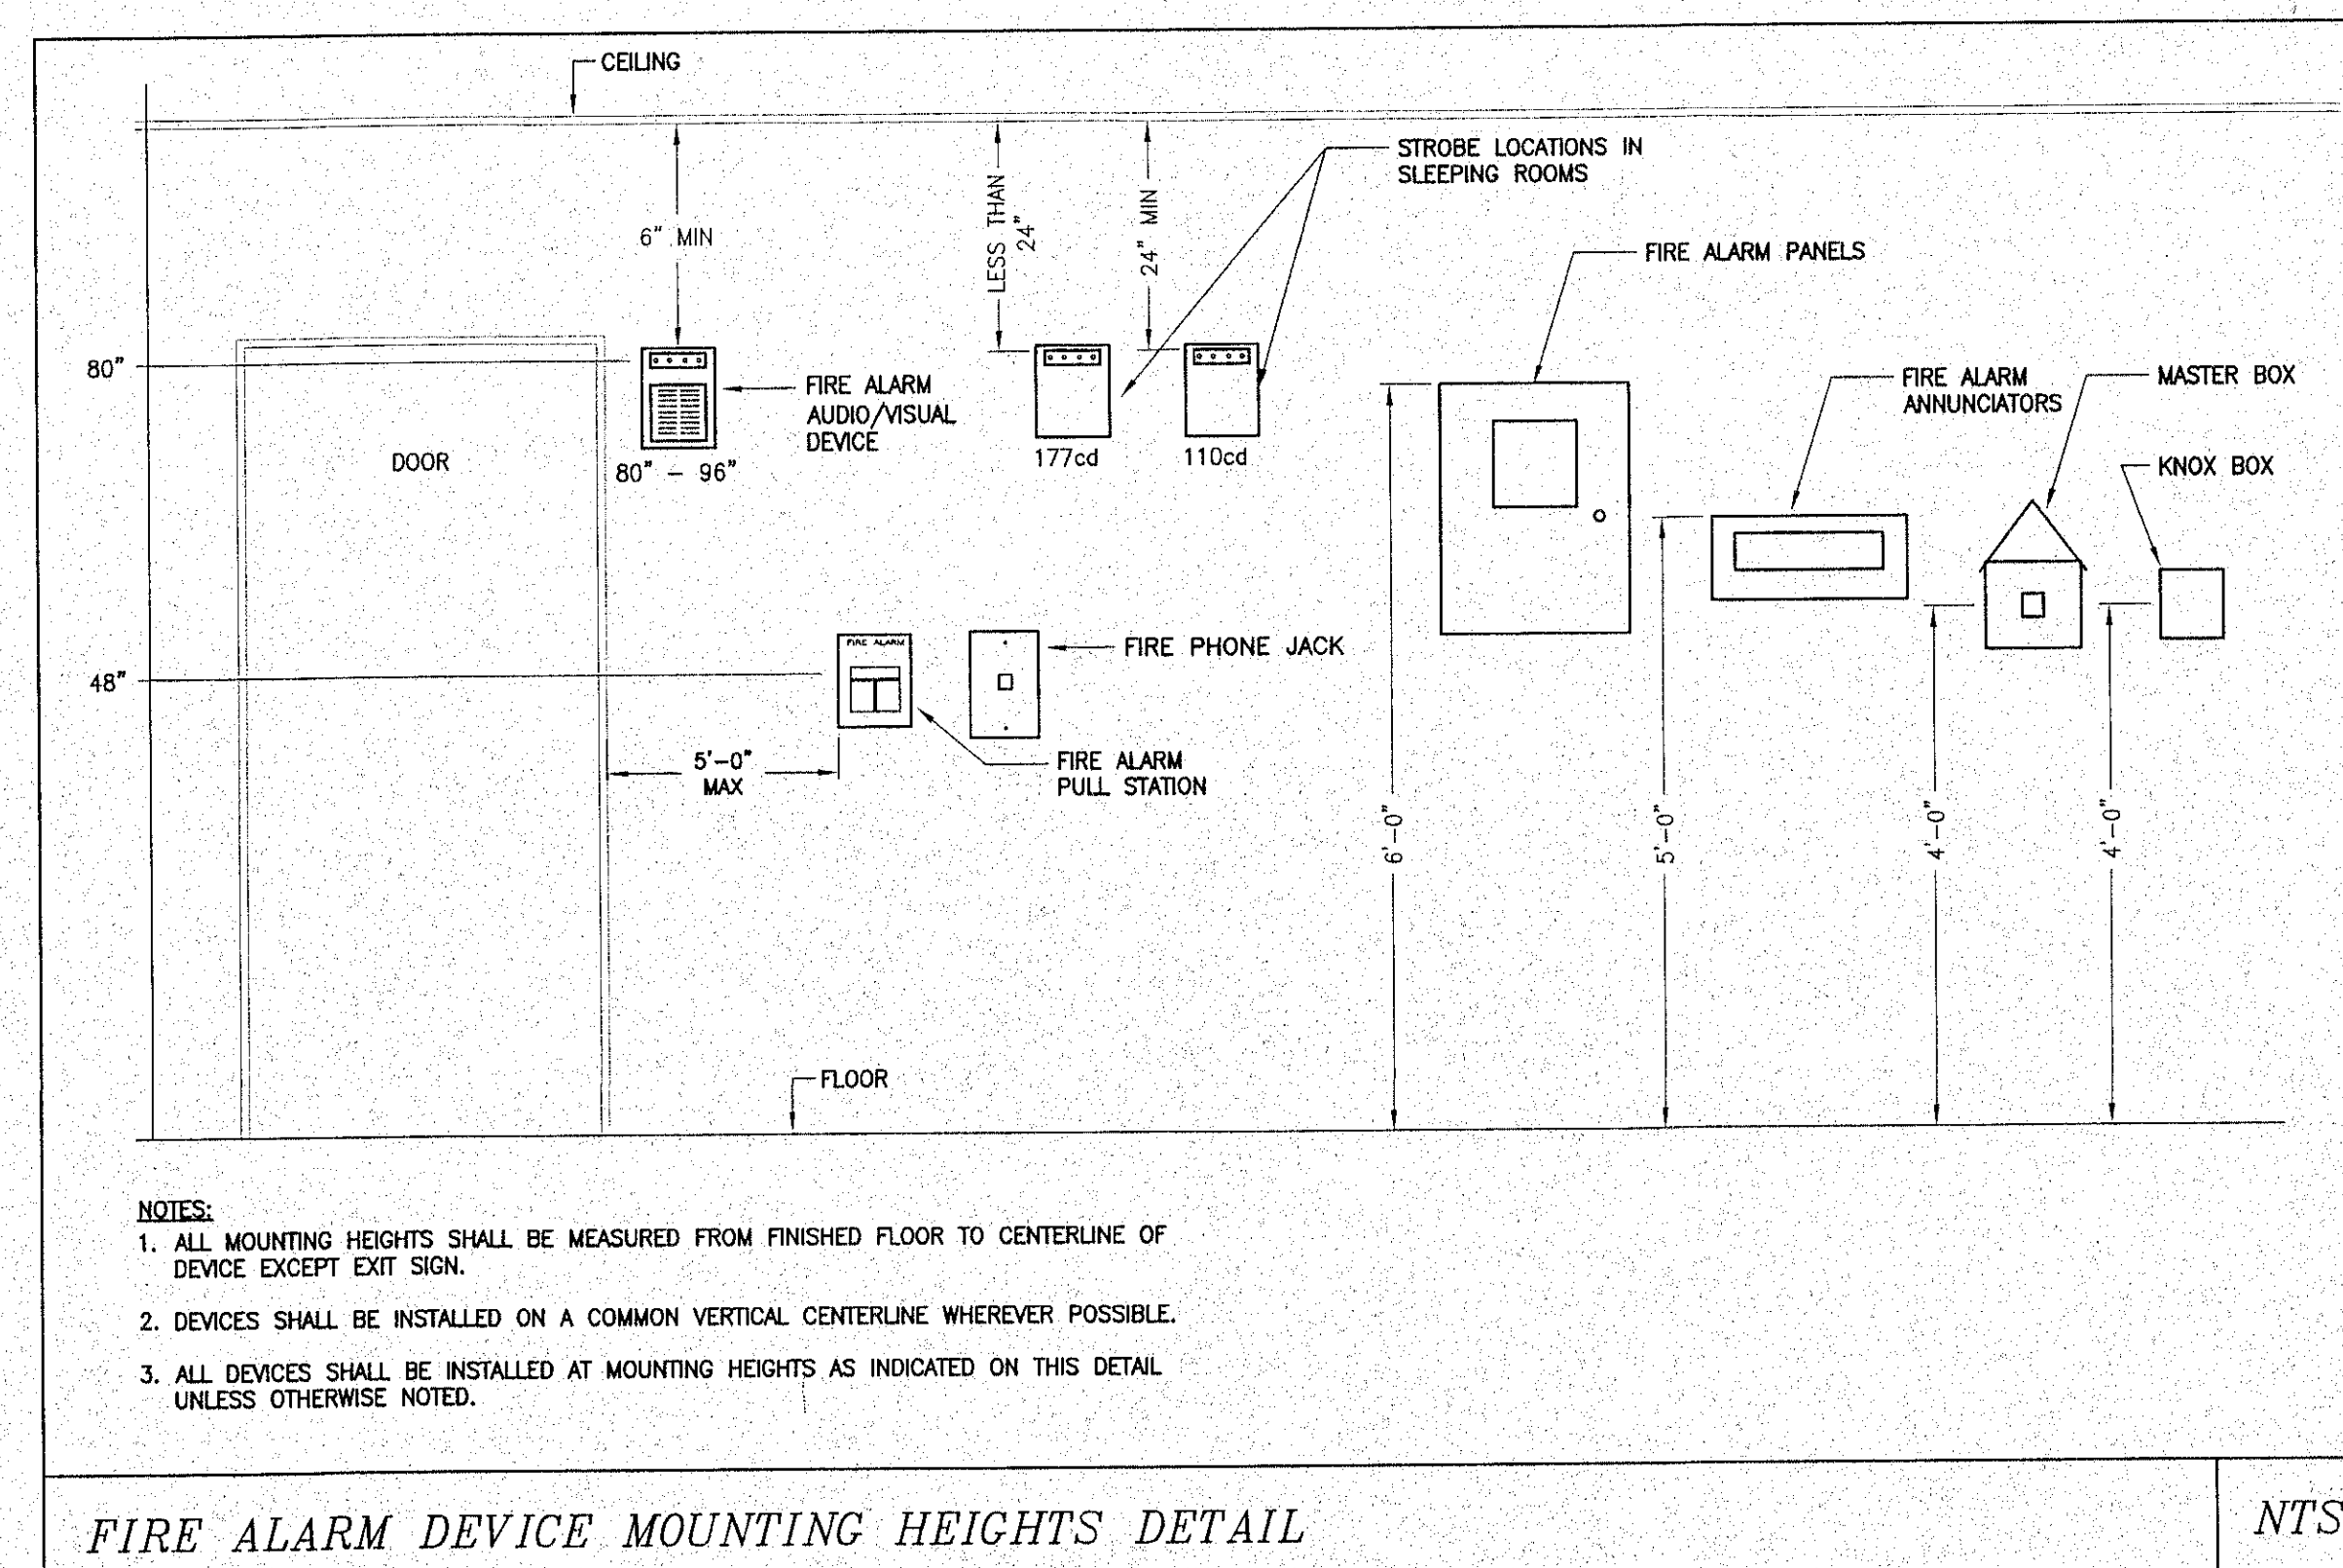
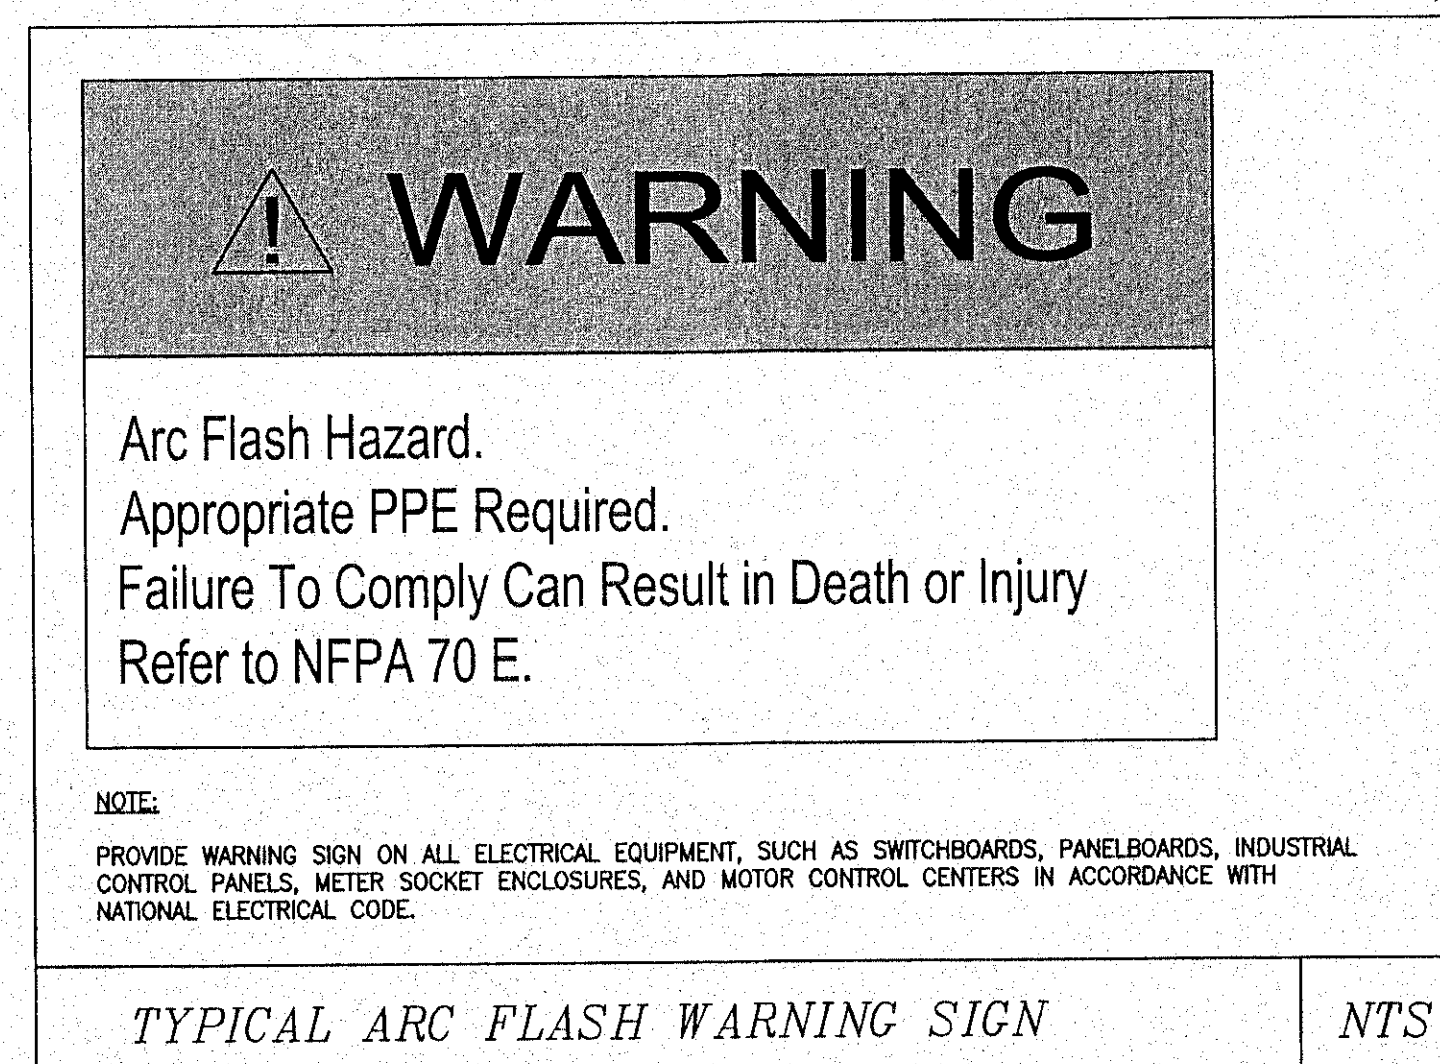
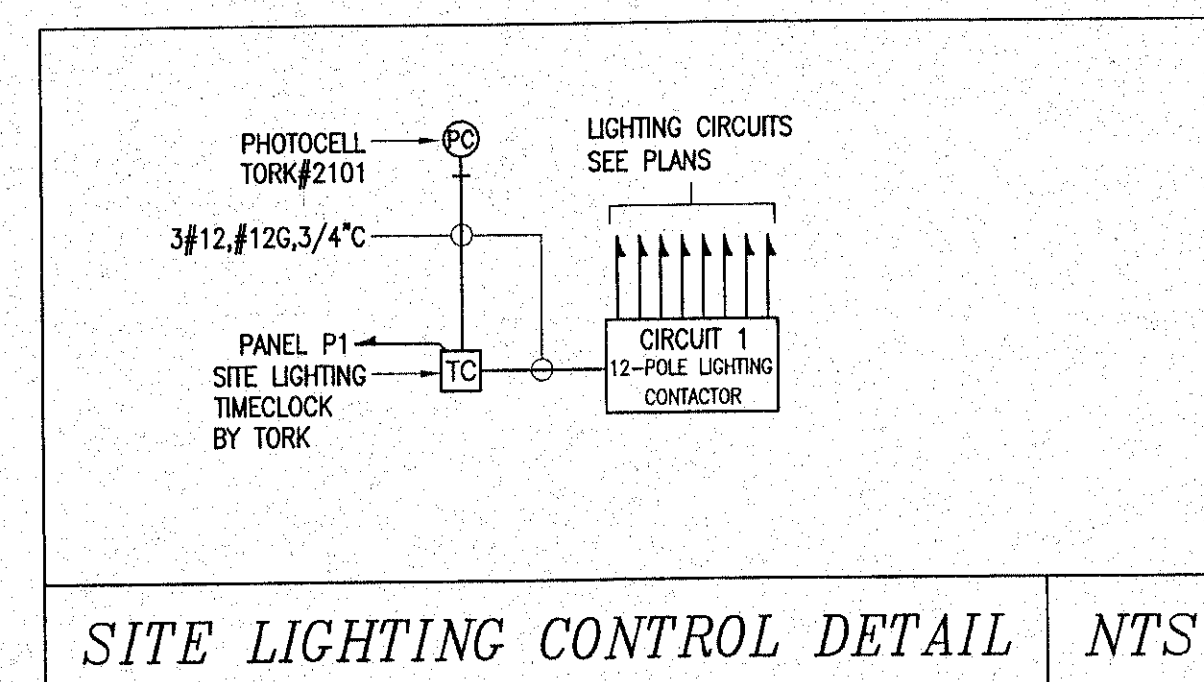
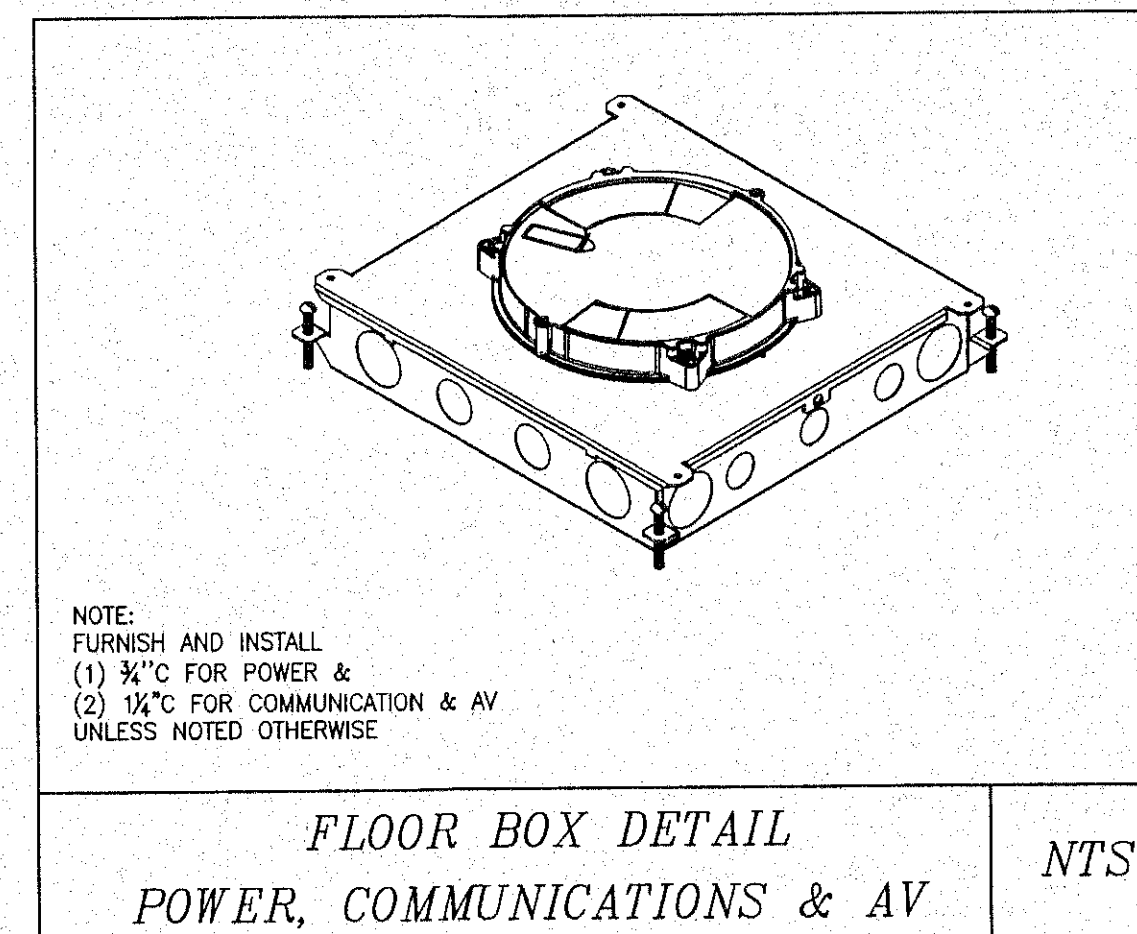


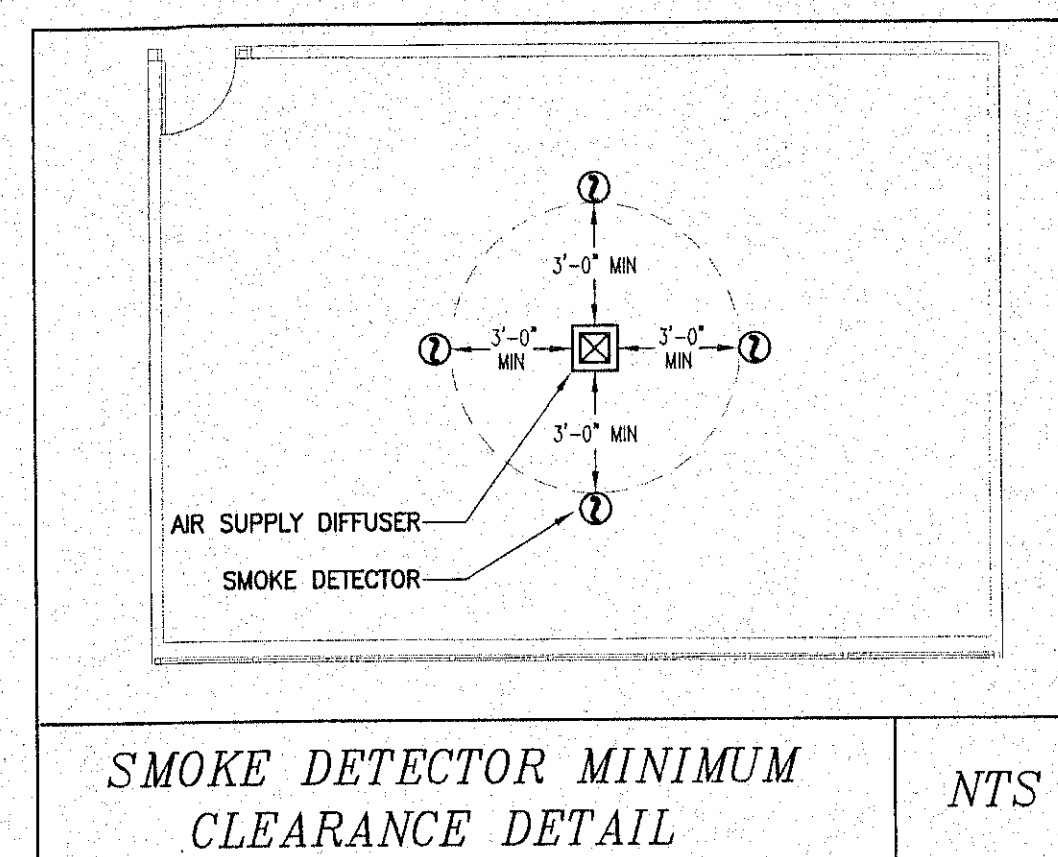

R.C. Searles Associates

 Exclusive Home Designers
Design / Build
 Phone No. 17 Cleaved St.

CONSULTING ARCHITECT
J THOMAS REARDON
7 SUNSET DRIVE
NORTHBOROUGH MA
01570

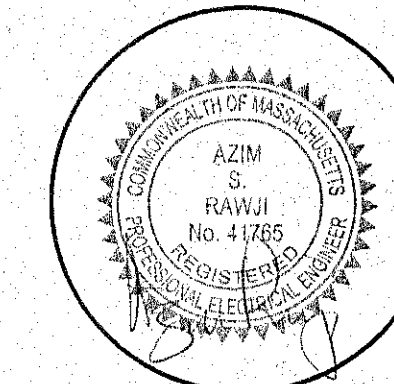

MENDON
POLICE
STATION

ELECTRICAL DETAILS

DATE: 12/21/12

SCALE: N.T.S.


DRAWN BY: NAJ

CHECKED BY: AR

Sheet 15 OF 25

E8

76 Webster Street
Worcester, MA 01603
508-797-0333 Phone
508-458-4111 Fax
www.engineering.us

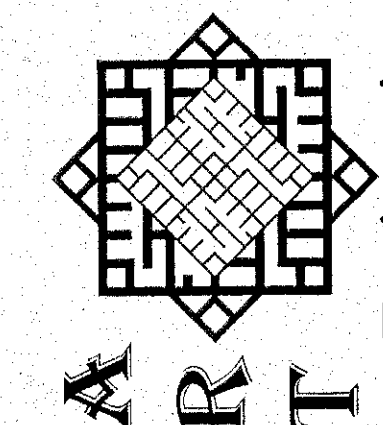

NOTICE OF COPYRIGHT

Pursuant to the Federal Copyright Act, these plans whether a preliminary layout or final construction set, partial set, bidding set, study set or extra prints, contain copyrightable material and are the property of R.C. Seales Associates, Inc. and its affiliates. All rights are reserved. No part of these plans may be used without the written consent of R.C. Seales Associates, Inc. These plans may be used only once, unless a signed written agreement between this office and client is approved. Any reproduction, including photocopying, re-use or formation of derivative work is expressly prohibited. Reproduction, including photocopying, re-use or formation of derivative work is expressly prohibited.

WWW.BCSEARLES.COM