



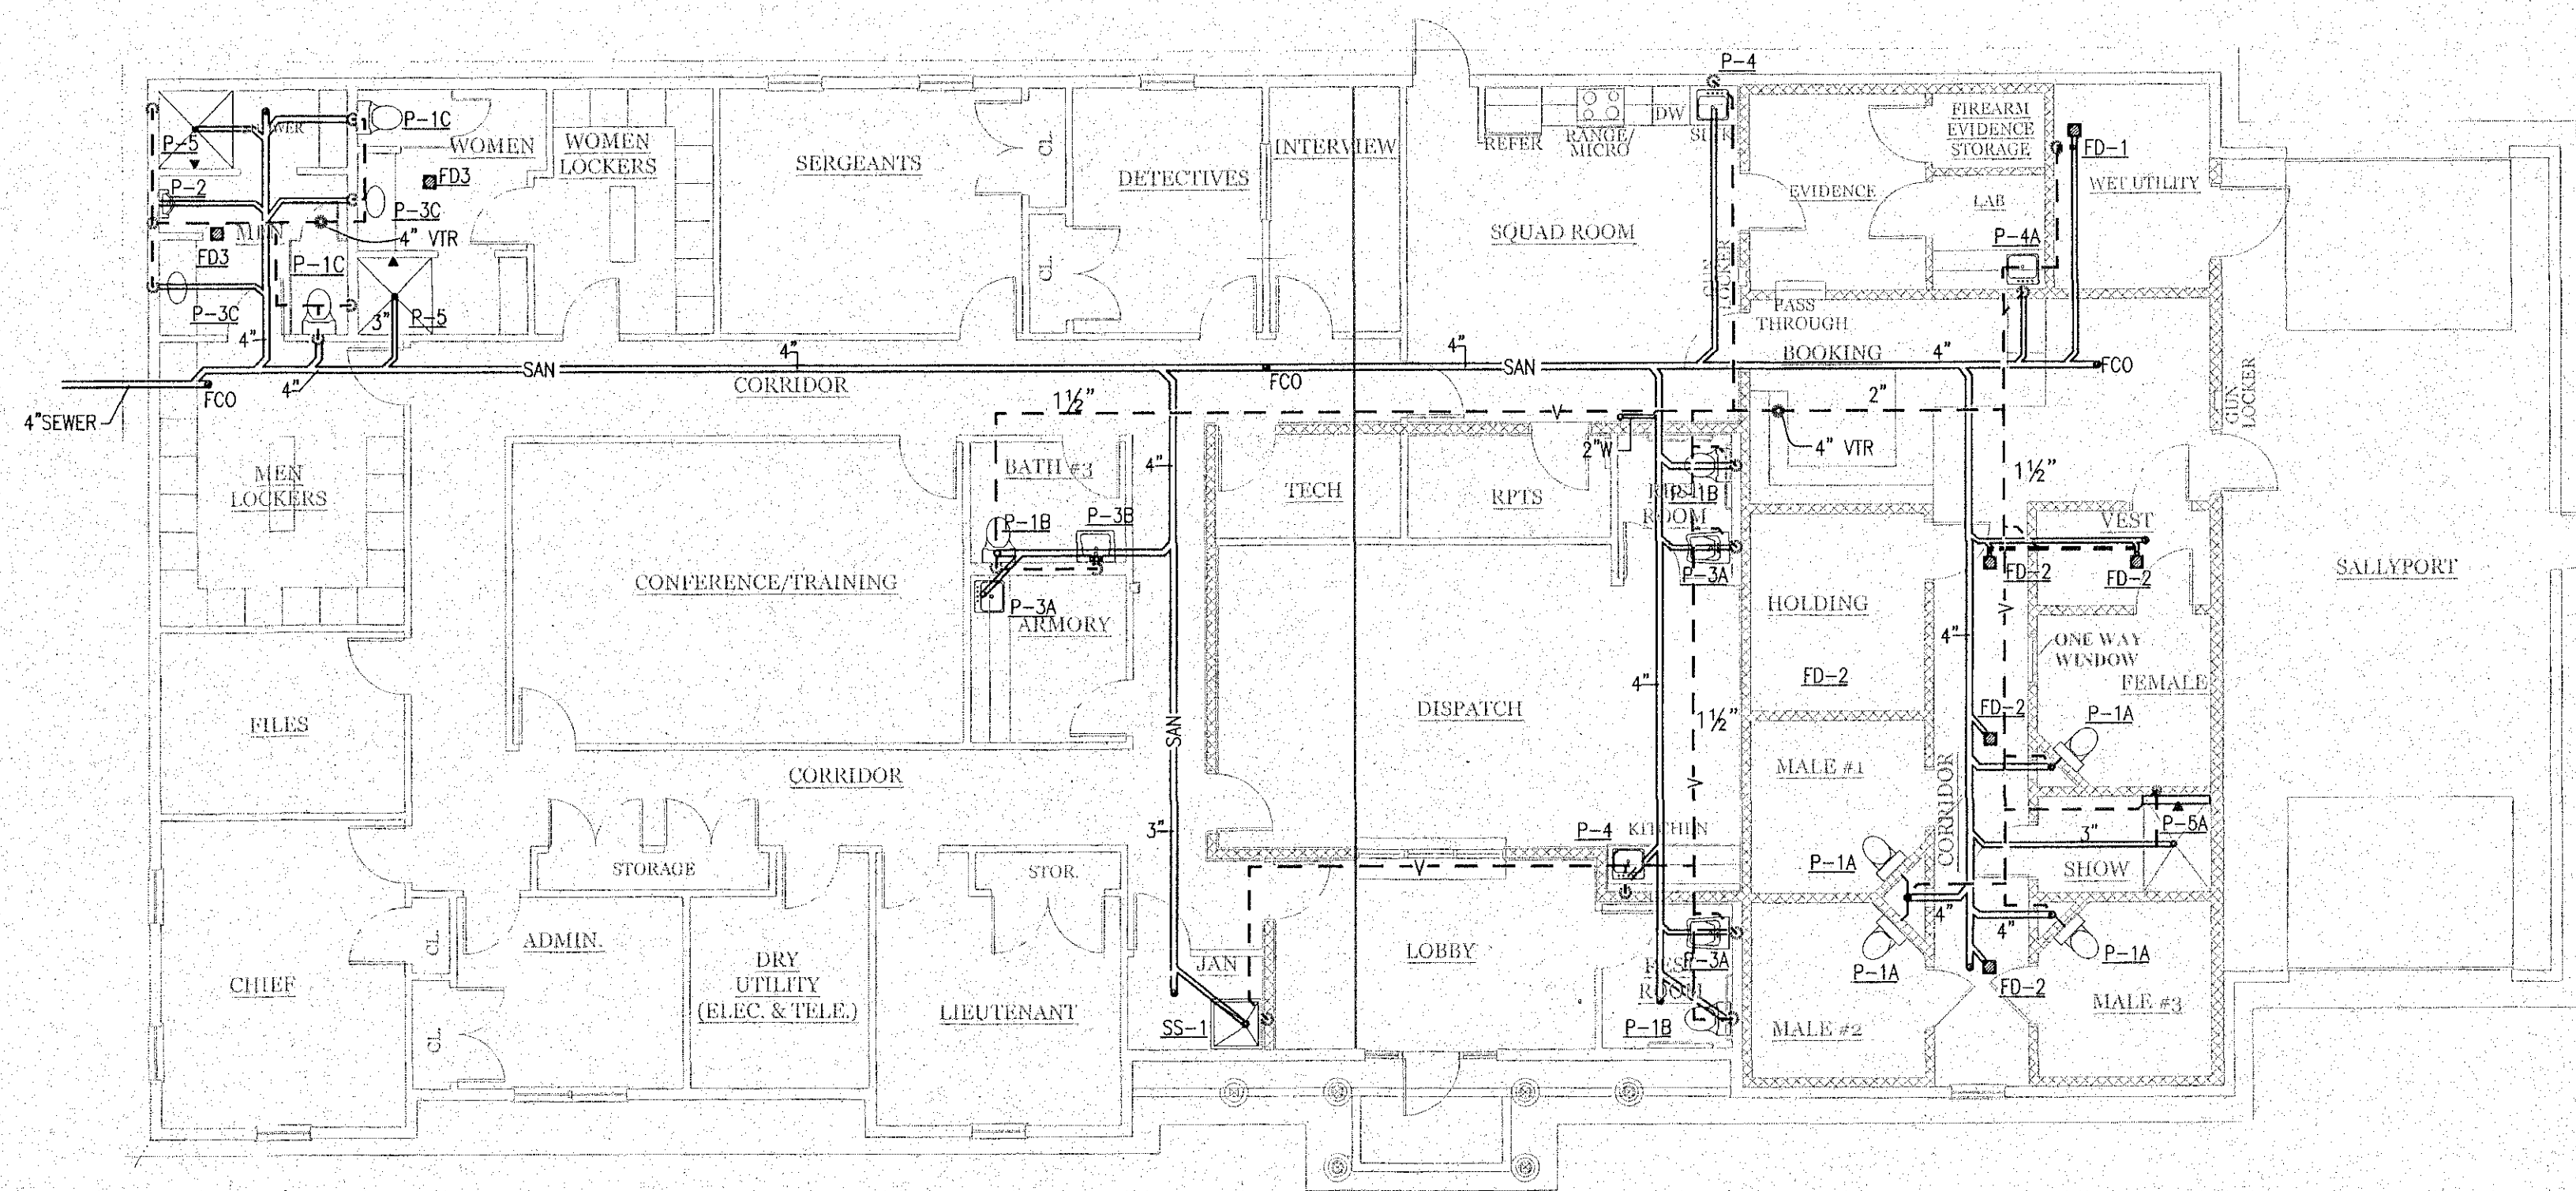


SEWER AND VENT PIPING
SCALE: 1/8"=1'-0"

NOTE: COORDINATE WELL WATER FLOW, PRESSURE AND OTHER REQUIREMENTS WITH OWNER. PROVIDE WATER FILTRATION, PRESSURE TANK ETC AS REQUIRED TO PROVIDE SUFFICIENT PRESSURE & FLOW TO THE PLUMBING FIXTURES.

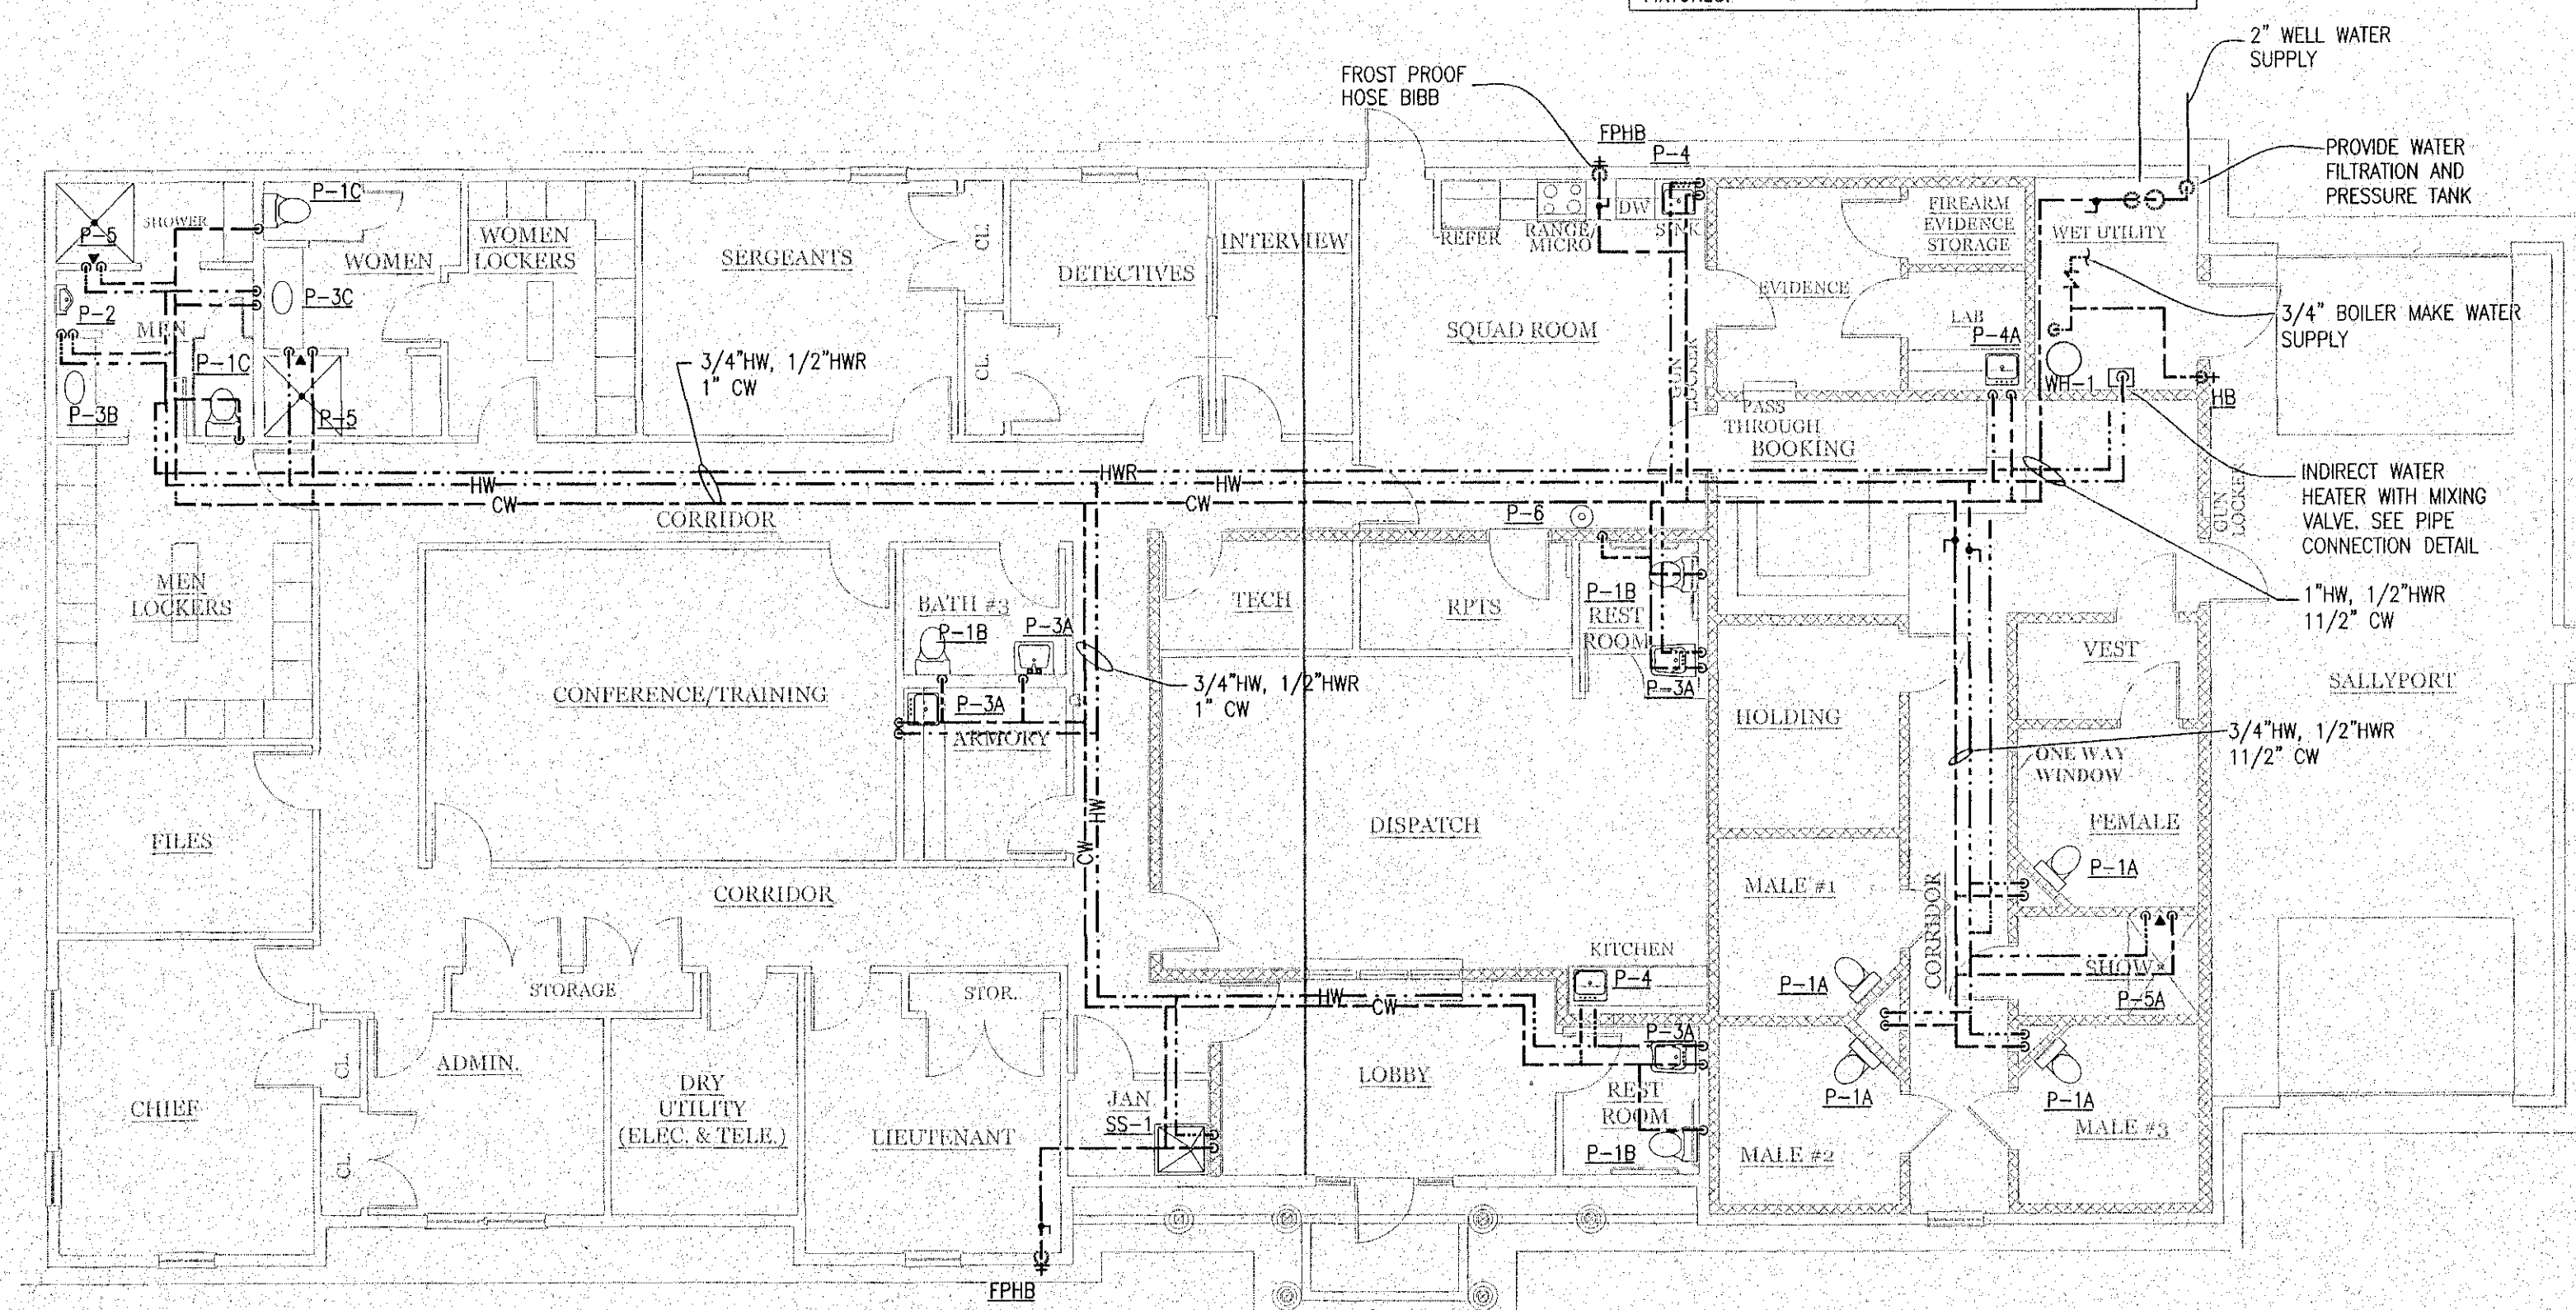


COLD AND HOT WATER PIPING
SCALE: 1/8"=1'-0"

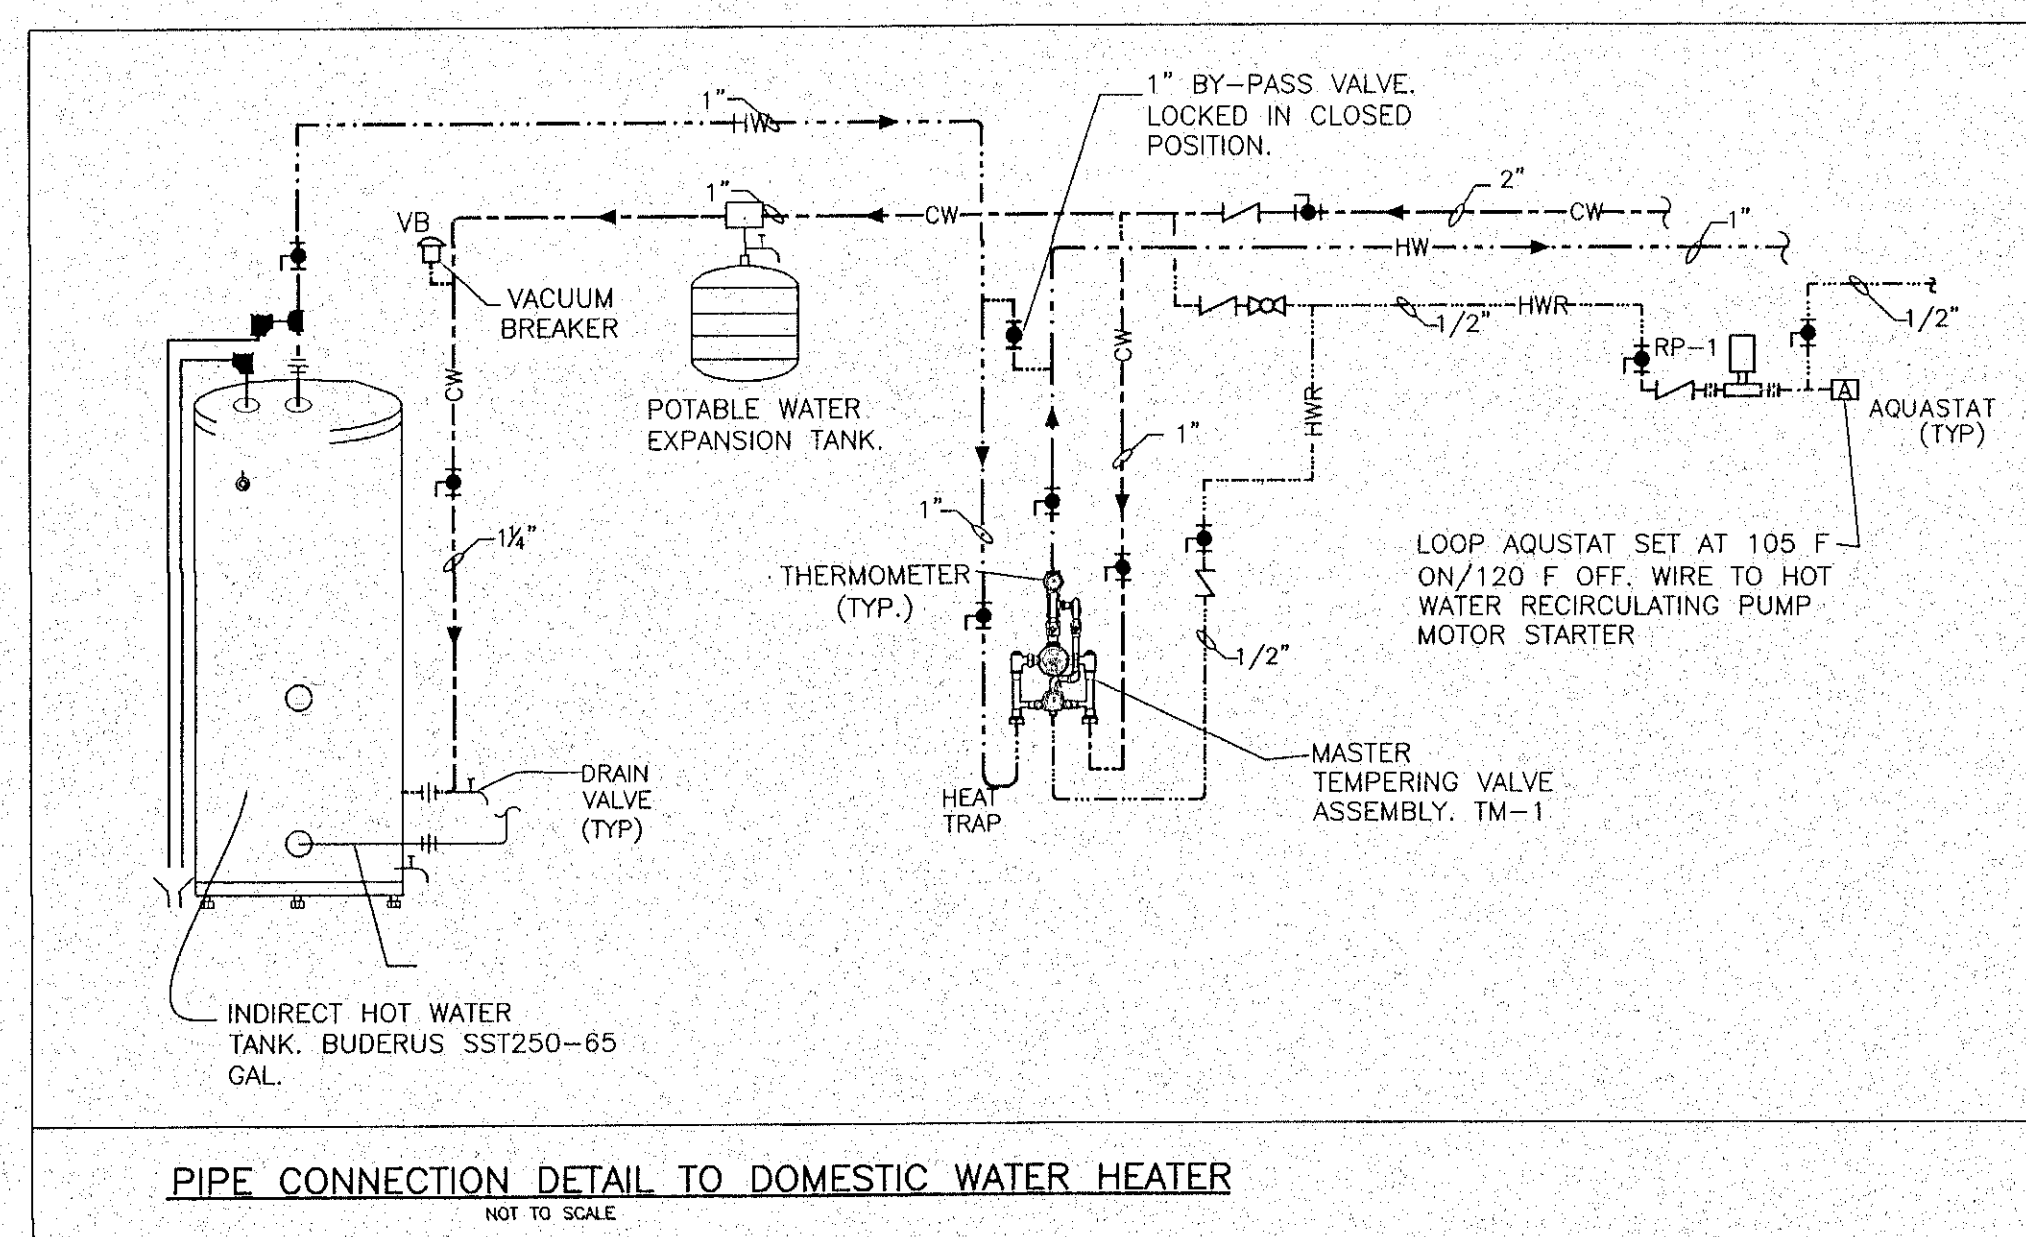

Akah Engineering Inc.
44 Central Street, Unit # 4
Berlin, MA. 01503
Telephone - (508) 869-0403
Fax - (508) 869-2891
www.akahengineering.com

R.C. Searles Associates
Exclusive Home Designers
Design / Build
Phone No. 17 Glenwood St.
(508) 466-3202 Holden Ma.

NOTICE OF COPYRIGHT
Pursuant to the Federal Copyright Act, these plans, whether a preliminary layout or final set, are the property of R.C. Searles Associates, Inc. and are not to be reproduced, stored in a retrieval system, or transmitted in any form or by any means, electronic, mechanical, photocopying, recording, or by any information storage and retrieval system, without the prior written permission of R.C. Searles Associates, Inc. These plans may be used only once, unless a signed written agreement between this office and client is approved. Any re-drawing, tracing, reproduction, re-use or formation of derivative work is expressly prohibited and any violators will be prosecuted to the fullest extent of the law.

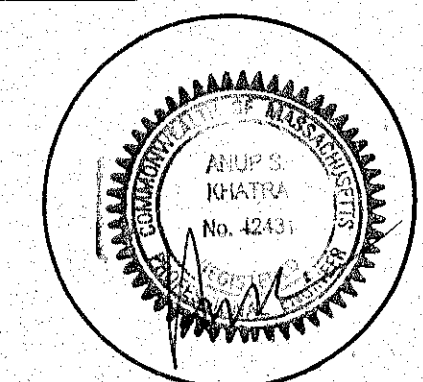

DATE: 12/21/12

SCALE:

DRAWN BY: JP

CHECKED BY: AK

Sheet 24 OF 25

P-1